



HAWAII ARMY NATIONAL GUARD
PHYSICAL SECURITY AND IMPROVEMENTS
WAIAWA PERIMETER FENCE
WAIAWA (PEARL CITY), HAWAII

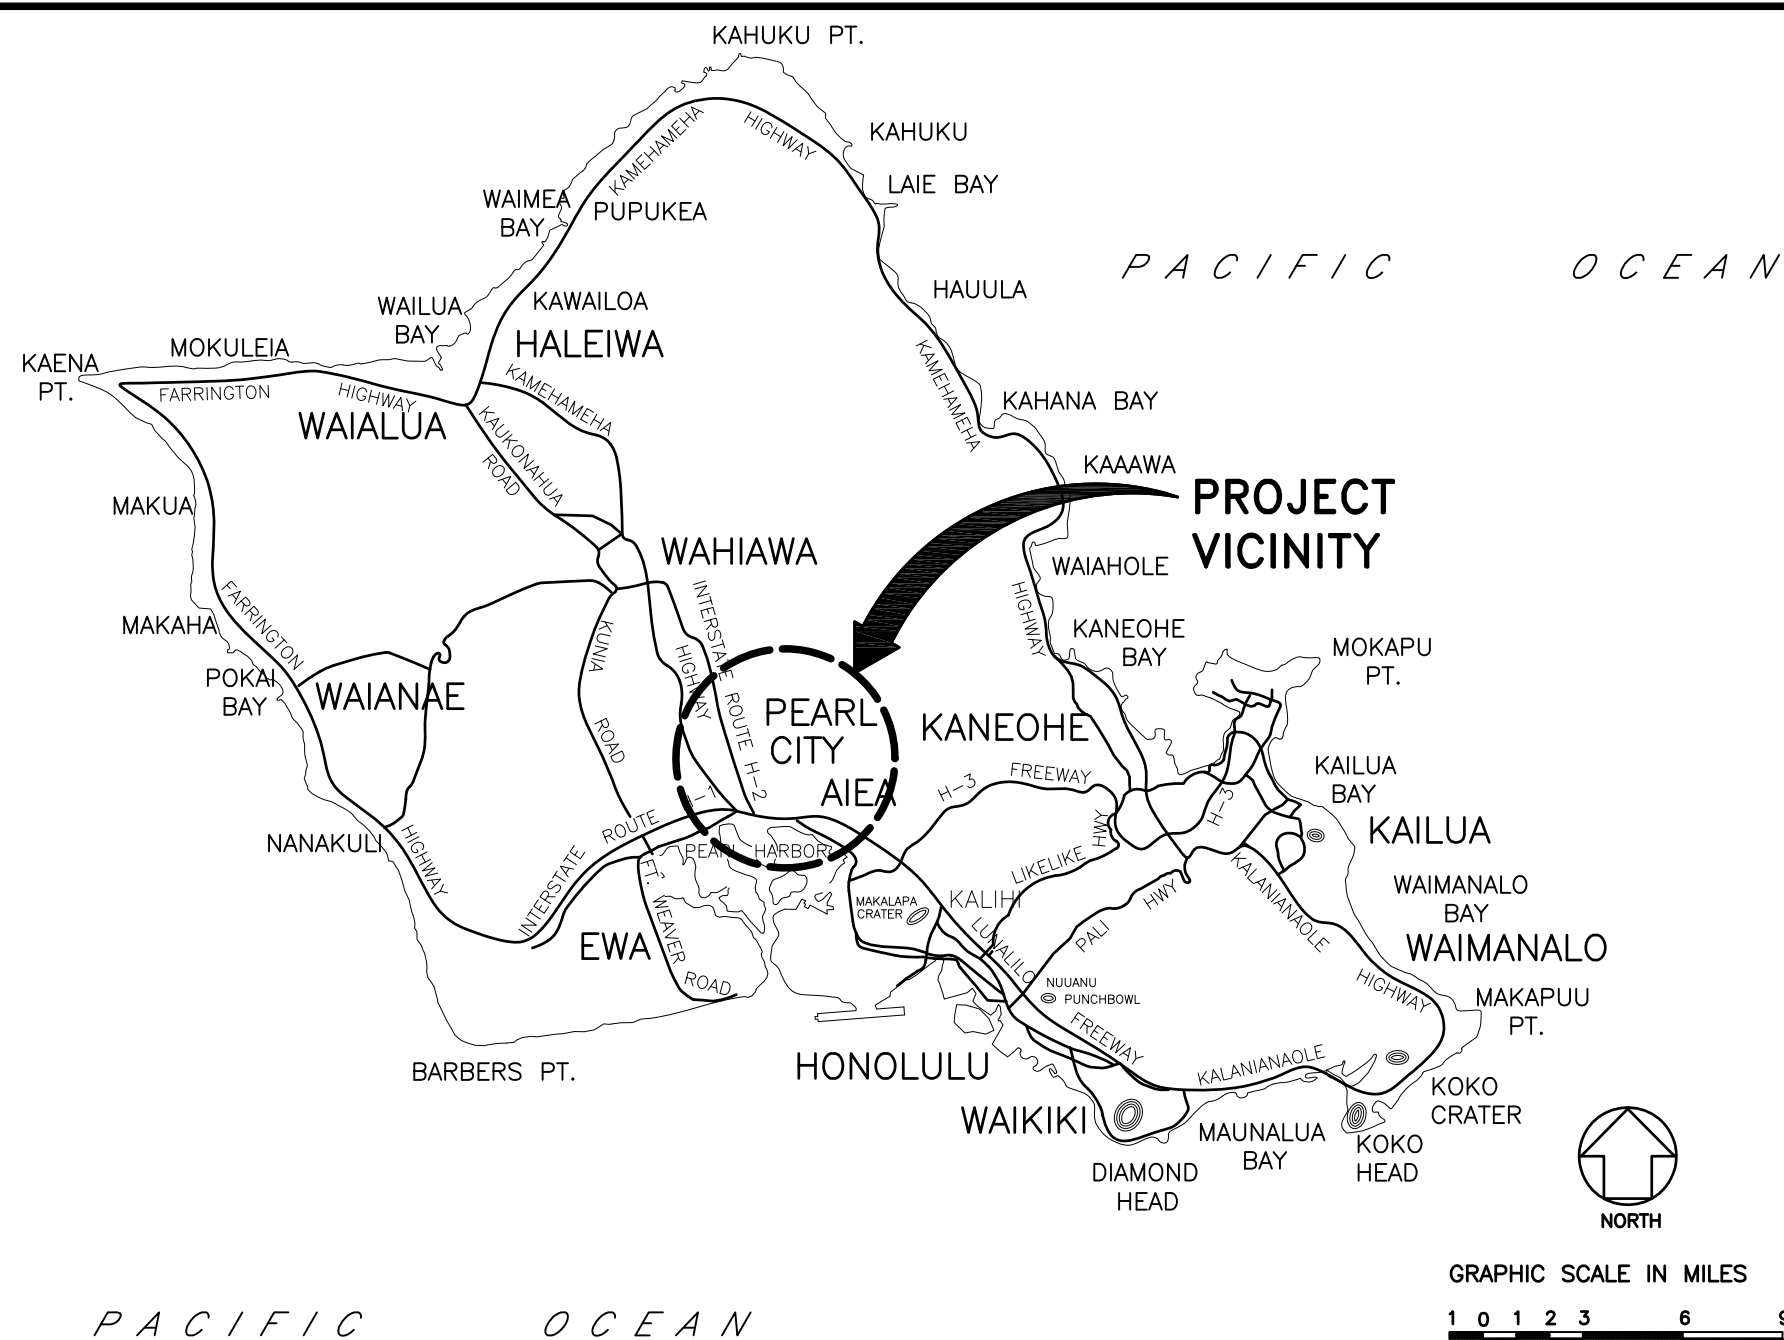

VICINITY MAP



LOCATION MAP

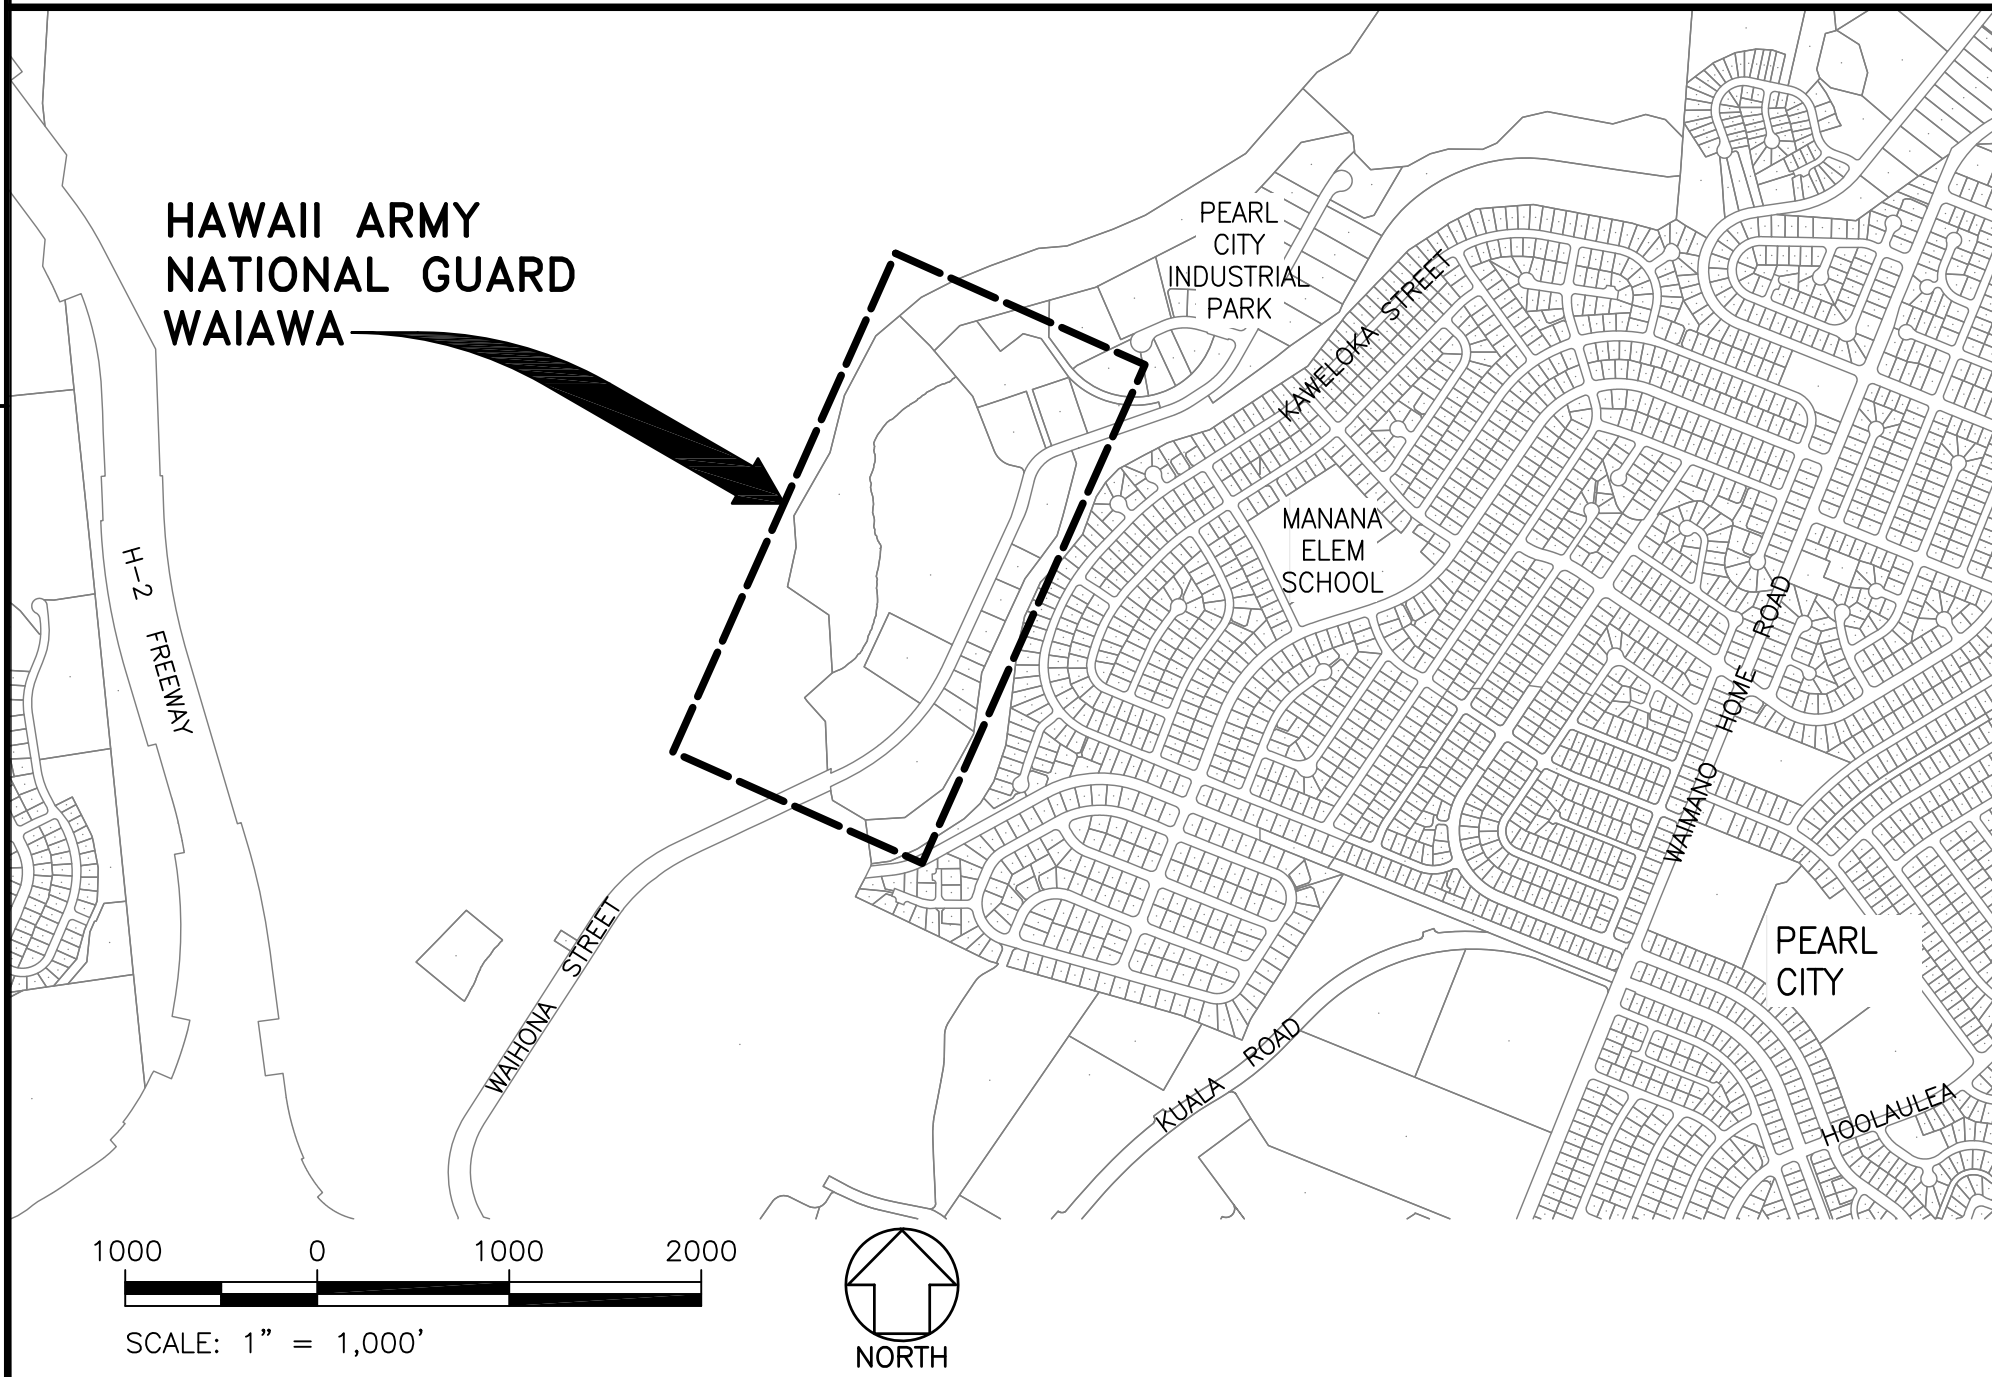

INDEX OF DRAWINGS

SHEET NO.	DWG NO.	DESCRIPTION
1	G-01	TITLE SHEET, LOCATION MAP, VICINITY MAP, AND INDEX OF DRAWINGS
2	G-02	SYMBOLS AND ABBREVIATIONS
3	G-03	GENERAL NOTES, SHEET 1
4	G-04	GENERAL NOTES, SHEET 2
5	G-05	GENERAL LOCATION AND KEY PLAN
6	G-06	EXISTING CONDITIONS PLAN, SHEET 1
7	G-07	EXISTING CONDITIONS PLAN, SHEET 2
8	G-08	EXISTING CONDITIONS PLAN, SHEET 3
9	C-01	DEMOLITION SITE PLAN
10	C-02	GENERAL CIVIL KEY PLAN
11	C-03	SITE PLAN, SHEET 1
12	C-04	SITE PLAN, SHEET 2
13	C-05	SITE PLAN, SHEET 3
14	C-06	FENCE PLOT PLAN PLAN, SHEET 1
15	C-07	FENCE PLOT PLAN PLAN, SHEET 2
16	C-08	TYPICAL SECTIONS, DRAINAGE PLOT PLAN
17	C-09	CIVIL DETAILS, SHEET 1
18	C-10	CIVIL DETAILS, SHEET 2
19	C-11	CIVIL DETAILS, SHEET 3
20	C-12	CIVIL DETAILS, SHEET 4
21	E-01	ELECTRICAL SYMBOLS AND NOTES
22	E-02	SITE ELECTRICAL PLAN
23	E-03	PULLBOX DETAILS
24	E-04	DUCT SECTION DETAILS
25	E-05	ONE-LINE DIAGRAM, PANEL SCHEDULES AND GUARD SHACK DETAIL

SUBMITTAL PHASE		FINAL			
SUBMITTAL DATE		03/02/15			
DES	ET	DRW	BY	CHK	RA
DEPARTMENT OF DEFENSE DESIGN AND PROJECT MANAGEMENT BRANCH HONOLULU, HAWAII		WAIAWA PERIMETER FENCE			
STATE OF HAWAII FACILITY MANAGEMENT OFFICE HIARNG		TITLE SHEET, LOCATION MAP, VICINITY MAP, AND INDEX OF DRAWINGS			
SCALE:		AS NOTED			
STATE JOB NO.		CA-1328-D			
FEDERAL PROJECT NO.		15140023			
SHEET		1		OF	25
G-01					

D

C

B

A

DATE: 08/28/14
SCALE: 1" = 1'
FILE: 2013033-102

TOL
+/-
PM: 08/28/14
OFFER: 12/04/14
REV. 1

GENERAL NOTES:

1.

ELEVATIONS SHOWN ARE BASED ON MEAN SEA LEVEL ELEVATION (ELEVATION = 0 FEET).
2.

DIMENSIONS TAKE PRECEDENCE OVER SCALE.
3.

THE TOPOGRAPHIC SURVEY WAS PREPARED BY CONTROLPOINT SURVEYING INC. DATED MAY 2014 AND SUPPLEMENTARY INFORMATION FROM RECORD DRAWINGS AND FIELD INVESTIGATIONS BY HDR. THE DRAWINGS DO NOT REFLECT SITE CHANGES THAT HAVE OCCURRED SINCE THE TOPOGRAPHIC SURVEY WAS COMPLETED.
4.

AZIMUTHS ARE REFERENCED FROM TRUE SOUTH = 0° 00' 00" AND INCREASE CLOCKWISE.
5.

DURING NON-WORKING HOURS, ALL TRENCHES AND EXCAVATIONS SHALL BE BARRICADED, COVERED AND/OR MARKED.
6.

THE EXISTENCE AND LOCATION OF UNDERGROUND UTILITIES AND STRUCTURES AS SHOWN ON THE PLANS ARE BASED ON THE AVAILABLE DATA. THE CONTRACTOR SHALL TONE THE PROJECT AREA, VERIFY THE LOCATIONS AND DEPTHS OF THE EXISTING UTILITIES SHOWN AND EXERCISE CARE WHEN EXCAVATING IN THE AREA.

WHEREVER CONNECTIONS AND CROSSINGS OF PROPOSED UTILITIES TO EXISTING UTILITIES ARE SHOWN, THE CONTRACTOR SHALL EXPOSE THE EXISTING LINES AT THE PROPOSED CONNECTIONS TO VERIFY THEIR LOCATIONS AND DEPTHS PRIOR TO EXCAVATION FOR THE NEW LINES. IF UTILITIES NOT SHOWN ARE ENCOUNTERED, OR IF POTENTIAL UTILITY CONFLICTS ARISE, NOTIFY THE PROJECT MANAGER IMMEDIATELY. THE CONTRACTOR SHALL PROVIDE STRUCTURAL SUPPORT FOR ALL EXISTING UTILITY LINES UNCOVERED IN THE TRENCHES.
7.

IF EXISTING UTILITIES, WHETHER OR NOT SHOWN ON PLANS, ARE DAMAGED DURING CONSTRUCTION THE CONTRACTOR SHALL REPAIR SUCH UTILITIES AT HIS OWN EXPENSE.
8.

CONTRACTOR SHALL, AT HIS OWN EXPENSE, KEEP THE PROJECT AREA AND SURROUNDING AREA FREE FROM DUST NUISANCE AND WITHIN ALLOWABLE NOISE LEVELS. THE WORK SHALL BE IN CONFORMANCE WITH AIR POLLUTION CONTROL STANDARDS AND REGULATIONS OF THE STATE DEPARTMENT OF HEALTH.
9.

THE CONTRACTOR SHALL REMOVE ALL SILT AND DEBRIS RESULTING FROM HIS WORK DEPOSITED IN DRAINAGE FACILITIES, ROADWAYS AND OTHER AREAS. THE COSTS INCURRED FOR ANY NECESSARY REMEDIAL ACTION SHALL BE PAYABLE BY THE CONTRACTOR.
10.

EXISTING SITE DRAINAGE SYSTEMS SHALL BE FUNCTIONAL AT ALL TIMES.
11.

PRIOR TO COMMENCING EXCAVATION, THE CONTRACTOR SHALL NOTIFY THE PROJECT MANAGER. THE CONTRACTOR SHALL COORDINATE, BE HELD RESPONSIBLE AND PAY FOR ALL DAMAGE TO EXISTING UTILITIES AND STRUCTURES. PERSONAL INJURY RESULTING FROM CONTACT WITH THE EXISTING UTILITIES SHALL BE THE CONTRACTOR'S RESPONSIBILITY.
12.

EXISTING UTILITIES SHALL REMAIN IN-SERVICE AND IN PLACE. IF RELOCATION OF EXISTING UTILITIES, WHETHER OR NOT SHOWN ON PLANS, IS REQUIRED FOR THE CONTRACTOR'S CONVENIENCE, INTERRUPTION OF SERVICE SHALL BE KEPT TO A MINIMUM AND SHALL BE DONE AT THE CONTRACTOR'S EXPENSE AND ONLY WITH THE APPROVAL OF THE PROJECT MANAGER.
13.

IF DEWATERING IS REQUIRED, DISPOSE DEWATERING EFFLUENT WITHOUT DISCHARGE TO WATERS OF THE STATE OF HAWAII, STORM DRAIN SYSTEMS, DRAINAGE SWALES, ETC. THE DEWATERING EFFLUENT WILL NOT BE ALLOWED TO POND, EXCEPT IN AREAS APPROVED BY THE PROJECT MANAGER. IF DISCHARGE OF DEWATERING EFFLUENT IS REQUIRED, CONTRACTOR IS RESPONSIBLE TO OBTAIN A NATIONAL POLLUTANT DISCHARGE ELIMINATION SYSTEM (NPDES) PERMIT PRIOR TO DISCHARGING TO THE STORM DRAINAGE SYSTEM. DEWATERING INTO SANITARY SEWER SYSTEM IS PROHIBITED.
14.

THE CONTRACTOR SHALL RESTORE TO THEIR ORIGINAL CONDITION, WHETHER OR NOT SHOWN ON PLANS, ALL IMPROVEMENTS DAMAGED AS A RESULT OF THE CONSTRUCTION, INCLUDING PAVEMENTS, EMBANKMENTS, CURBS, SIGNS, LANDSCAPING, STRUCTURES, UTILITIES, WALLS, FENCES, ETC. UNLESS PROVIDED FOR SPECIFICALLY IN THE PROPOSAL AT CONTRACTOR'S EXPENSE.
15.

THE CONTRACTOR SHALL OBTAIN AND PAY FOR ALL PERMITS AND LICENSES REQUIRED. THE CONTRACTOR SHALL CONDUCT ALL TESTS AS REQUIRED BY THE CONSTRUCTION MANAGER AND BE RESPONSIBLE FOR ALL EXPENSES INCURRED IN CONDUCTING THESE TESTS.
16.

THE CONTRACTOR SHALL VERIFY AND CHECK ALL DIMENSIONS, ELEVATIONS, AND DETAILS SHOWN ON THE DRAWINGS PRIOR TO START OF CONSTRUCTION. THE CONTRACTOR SHALL IMMEDIATELY NOTIFY THE PROJECT MANAGER OF ANY DISCREPANCY OR CONFLICT FOUND IN THE FIELD PRIOR TO OR DURING THE COURSE OF CONSTRUCTION AND SHALL NOT PROCEED WITH CONSTRUCTION UNTIL THE PROJECT MANAGER RESOLVES THE SAID DISCREPANCY OR CONFLICT. DIMENSIONS AND ELEVATIONS SHOWN ARE BASED ON LIMITED FIELD MEASUREMENTS AND ORIGINAL CONSTRUCTION DRAWINGS. DIMENSIONS AND ELEVATIONS FOR THE NEW WORK SHALL BE ADJUSTED AS REQUIRED BASED ON THE CONTRACTOR'S FIELD MEASUREMENTS WITH THE APPROVAL OF THE PROJECT MANAGER.

GENERAL NOTES (CONTINUED):

17.

THE CONTRACTOR SHALL BEAR ALL COSTS ASSOCIATED WITH THE REMOVAL/ AVOIDANCE OF ABANDONED UTILITIES, WHETHER OR NOT SHOWN ON PLANS.
18.

THE CONTRACTOR SHALL BE RESPONSIBLE FOR CONFORMANCE WITH THE APPLICABLE PROVISIONS OF THE WATER QUALITY AND WATER POLLUTION CONTROL STANDARDS CONTAINED IN THE HAWAII ADMINISTRATIVE RULES, TITLE 11, CHAPTER 54, "WATER QUALITY STANDARDS" AND TITLE 11, CHAPTER 55, "WATER POLLUTION CONTROL". BEST MANAGEMENT PRACTICES SHALL BE EMPLOYED AT ALL TIMES DURING THE CONSTRUCTION PERIOD.
19.

THE CONTRACTOR SHALL OBTAIN AND COMPLY WITH NPDES PERMIT REQUIREMENTS FOR ALL PROJECTS WHICH WILL DISTURB ONE (1) ACRE OR MORE OF LAND. THE CONTRACTOR SHALL NOT START CONSTRUCTION UNTIL NOTICE OF GENERAL PERMIT COVERAGE IS RECEIVED FROM THE DEPARTMENT OF HEALTH, STATE OF HAWAII AND ANY OTHER APPLICABLE REQUIREMENTS OF THE NPDES PERMIT PROGRAM HAVE BEEN MET.
20.

IF CAVITIES AND/OR VOIDS ARE ENCOUNTERED DURING EXCAVATION WORK, STOP WORK IMMEDIATELY AND NOTIFY THE PROJECT MANAGER.
21.

CONFINE ACTIVITIES WITHIN THE PROJECT LIMITS.
22.

PROJECT MANAGER IS THE COORDINATOR BETWEEN THE CONTRACTOR AND ACTIVITY. NOTIFY THE PROJECT MANAGER PRIOR TO CONTACTING THE ACTIVITY. COORDINATE ALL WORK WITH THE PROJECT MANAGER TO ENSURE THAT CONSTRUCTION ACTIVITIES DO NOT INTERFERE WITH BASE OPERATIONS.
23.

THE CONTRACTOR SHALL OBSERVE AND COMPLY WITH ALL FEDERAL, STATE AND LOCAL LAWS REQUIRED FOR THE PROTECTION OF PUBLIC HEALTH, SAFETY AND ENVIRONMENTAL QUALITY.
24.

EM 385-1-1, SAFETY AND HEALTH REQUIREMENTS, AND WITH ALL APPLICABLE FEDERAL, SAFETY AND LOCAL LAWS REQUIRED FOR THE PROTECTION OF PUBLIC HEALTH, SAFETY AND ENVIRONMENTAL QUALITY. WHERE REQUIREMENTS VARY, THE MOST STRINGENT REQUIREMENTS SHALL APPLY.
25.

THE CONTRACTOR SHALL PROVIDE SAFE ACCESS TO AND FROM ALL DRIVEWAYS AND STREETS.
26.

THE CONTRACTOR SHALL PLAN OPERATIONS TO MINIMIZE THE AMOUNT OF EXCAVATED TRENCHES LEFT OPEN AT THE END OF EACH WORK DAY WITH THE TOTAL LENGTH OF OPEN TRENCHES NOT TO EXCEED 500 FEET. OPEN TRENCHES SHALL BE COVERED BY NON-SKID STEEL PLATES CAPABLE OF CARRYING H-20 VEHICLES IN TRAFFIC AREAS AND 100 POUNDS PER SQUARED FOOT IN NON-TRAFFIC AREAS. PROVIDE ANCHORING OF THE PLATES IN NON-TRAFFIC AREAS. PROVIDE FLASHING BARRICADES TO DELINEATE COVERED TRENCHES IN NON-TRAFFIC AREAS AND ALL STOCK/SPOIL PILES.
27.

WHEREVER EXISTING FENCE IS REMOVED, REINSTALL CHAIN LINK FENCE AS NECESSARY TO SECURE PROTECTED AREAS PRIOR TO THE END OF EACH WORK DAY. TRENCHES CROSSING ANY FENCE, EXISTING OR PROVIDED, SHALL NOT BE LEFT OPEN DURING NON-WORK HOURS. BACKFILL A MINIMUM OF 10 FEET ON EACH SIDE OF FENCE AT THE END OF WORK DAY. OTHER MEASURES MAY BE UTILIZED AS APPROVED BY THE PROJECT MANAGER.
28.

CONTRACTOR SHALL COORDINATE WITH PROJECT MANAGER TO HAVE HIARNG WAIAWA COMPLEX PROPERTY LINE ESTABLISHED BY INSTALLING SURVEY PINS/MARKERS AT ALL PROPERTY LINE CORNERS. PROPERTY LINE ESTABLISHMENT OF SURVEY PINS/MARKERS SHALL BE COMPLETED BY A LICENSED PROFESSIONAL LAND SURVEYOR.
29.

CONTRACTOR SHALL LOCATE AND VERIFY ALL HIARNG WAIAWA COMPLEX PROPERTY LINE CORNERS AND STAKE PROPERTY LINE OUT PRIOR TO NEW FENCE AND GATE REPLACEMENT AND INSTALLATION. CONTRACTOR SHALL ENSURE THAT NEW FENCES AND GATES ARE INSTALLED WITHIN HIARNG WAIAWA COMPLEX PROPERTY LINE.

ARCHAEOLOGICAL NOTES:

1.

PURSUANT TO CHAPTER 6E OF THE HAWAII REVISED STATUTES, ALL CONTRACTORS SHALL ENSURE THAT IN THE EVENT THAT ANY HUMAN SKELETAL REMAINS ARE INADVERTENTLY DISCOVERED DURING CONSTRUCTION, THE REMAINS SHALL NOT BE MOVED AND ANY ACTIVITY IN THE IMMEDIATE AREA THAT COULD DAMAGE THE REMAINS OR THE POTENTIAL HISTORIC SITE SHALL CEASE AND THE DEPARTMENT OF LAND AND NATURAL RESOURCES' HISTORIC PRESERVATION DIVISION (TELEPHONE: 243-5119), THE APPROPRIATE MEDICAL EXAMINER OR CORONER, AND THE POLICE DEPARTMENT (TELEPHONE: 244-6400), SHALL BE CONTACTED. SEE SECTION 00710, "GENERAL CONDITIONS", PARAGRAPH 6.6, "UNAVOIDABLE DELAYS" IF ARCHAEOLOGICAL FINDINGS RESULT IN UNAVOIDABLE DELAYS TO THE PROJECT.
2.

CAREFULLY PROTECT IN-PLACE AND REPORT IMMEDIATELY TO THE PROJECT MANAGER HISTORICAL AND ARCHAEOLOGICAL ITEMS, HUMAN SKELETAL REMAINS, STONE WALLS, STONE TOOLS, SHELL MIDDENS OR CHARCOAL DEPOSITS DISCOVERED IN THE COURSE OF WORK. STOP WORK IN THE IMMEDIATE AREA OF THE DISCOVERY UNTIL DIRECTED BY THE PROJECT MANAGER TO RESUME WORK. THE PROJECT MANAGER MAY REQUIRE THE CONTRACTOR TO RELOCATE TO OTHER PORTIONS OF THE PROJECT WHILE RECOVERY OPERATIONS, IF NECESSARY, ARE CONDUCTED. THE CONTRACTOR SHALL FOLLOW THE DIRECTIONS OF THE HIARNG ENVIRONMENTAL BRANCH SHOULD ARTIFACTS AND BURIALS BE DISCOVERED.
3.

THE GOVERNMENT RETAINS OWNERSHIP AND CONTROL OVER HISTORICAL AND ARCHAEOLOGICAL RESOURCES.

TRAFFIC CONTROL NOTES:

1.

THE CONTRACTOR SHALL PROVIDE AND MAINTAIN ALL NECESSARY SIGNS, LIGHTS, FLARES, BARRICADES, MARKERS, CONES, AND OTHER PROTECTIVE FACILITIES SHALL CONFORM WITH THE TRAFFIC REGULATIONS "ADMINISTRATIVE RULES OF HAWAII GOVERNING THE USE OF TRAFFIC CONTROL DEVICES AT WORK SITES ON OR ADJACENT TO PUBLIC STREETS AND HIGHWAYS", ADOPTED BY THE DIRECTOR OF TRANSPORTATION, AND THE CURRENT U.S. FEDERAL HIGHWAY ADMINISTRATION "MANUAL ON UNIFORM TRAFFIC CONTROL DEVICES FOR STREETS AND HIGHWAYS, PART VI - STANDARDS AND GUIDES FOR TRAFFIC CONTROLS FOR STREET AND HIGHWAY CONSTRUCTION, MAINTENANCE, UTILITY, AND INCIDENT MANAGEMENT OPERATIONS".
2.

ALL LANES SHALL BE OPENED TO TRAFFIC DURING THE MORNING PEAK HOURS OF 6:30 A.M. TO 8:30 A.M. AND DURING THE AFTERNOON PEAK HOURS FROM 3:00 P.M. TO 5:00 P.M. DURING WORKING HOURS, TWO LANES OF TRAFFIC SHALL BE OPEN AT ALL TIMES. FOR STREETS WITH TWO LANES, ONLY ONE LANE OF TRAFFIC SHALL BE CLOSED AT ANY ONE TIME. THE CONTRACTOR SHALL PROVIDE AT LEAST TWO FLAGMEN TO DIRECT ALTERNATING TRAFFIC IN THE OPEN LANE. THE CONTRACTOR SHALL PROVIDE ONE LANE FOR TRAFFIC ACCESS TO ALL DRIVEWAYS, PARKING AREAS, ETC. AT ALL TIMES.
3.

DURING NON-WORKING HOURS, ALL LANES SHALL BE OPEN TO TRAFFIC. ALL TRENCHES SHALL BE COVERED WITH NON-SKID BRIDGING MATERIAL WITH SUITABLE MATERIAL AT THE EDGES TO PROVIDE A SMOOTH TRANSITION.
4.

WHEREVER PEDESTRIAN WALKWAYS EXIST, THEY SHALL BE MAINTAINED IN PASSABLE CONDITION OR OTHER FACILITIES FOR PEDESTRIANS SHALL BE PROVIDED. PASSAGE BETWEEN WALKWAYS AT INTERSECTIONS SHALL LIKEWISE BE PROVIDED.
5.

THE CONTRACTOR SHALL REPLACE OR REPAIR ALL TRAFFIC SIGNS, POSTS, AND MARKINGS DISTURBED BY THE CONTRACTOR'S ACTIVITIES TO EXISTING CONDITIONS OR BETTER.
6.

THE CONTRACTOR SHALL COORDINATE ALL TRAFFIC CONTROL PLANS WITH THE PROJECT MANAGER.



A/E INFO



SEAL

APPR

DATE

DESCRIPTION
SYM

SUBMITAL PHASE

FINAL

SUBMITAL DATE

03/02/15

DES ET DRW BTY CHK RA

DEPARTMENT OF DEFENSE
DESIGN AND PROJECT
MANAGEMENT BRANCH

HONOLULU, HAWAII

HAWAIIAN ARMY NATIONAL GUARD

PHYSICAL SECURITY AND IMPROVEMENTS

STATE OF HAWAII

FACILITY MANAGEMENT OFFICE

HIARNG

WAIAWA PERIMETER FENCE

GENERAL NOTES, SHEET 1

SCALE:

AS NOTED

STATE JOB NO.

CA-1328-D

FEDERAL PROJECT NO.

15140023

SHEET 3 OF 25

G-03

D

C

B

A

DATE: 08/28/14
SCALE: 1" = 1'
FILE: 2013033-103

TOL. FAULTY
PM: OFFER REV. _
DATE: _

ACCESS TO PROJECT SITE AND MAINTAINING HAWAII NATIONAL GUARD AREA PERIMETER SECURITY NOTES:

1. THE PROJECT IS GENERALLY LOCATED WITHIN A SECURED PERIMETER AREA HOUSING THE HAWAII ARMY NATIONAL GUARD WAIAWA COMPLEX. THE SECURED PERIMETER RUNS ALONG WAIHONA STREET. VEHICLE ACCESS IS CONTROLLED BY MAIN GATE WAIHONA STREET NEAR BUILDING 23317.
2. CONTRACTOR SHALL BE RESPONSIBLE TO COORDINATE WITH THE PROJECT MANAGER IMPACTS AND DISRUPTION TO GATE FACILITIES AND OPERATION(S). TEMPORARY RELOCATION OF GATE SECURITY FACILITIES AND TEMPORARY ACCESS CONTROL MAY BE BY THE HAWAII NATIONAL GUARD OR BY THE CONTRACTOR AS DIRECTED. CONTRACTOR SHALL BE RESPONSIBLE FOR ALL COSTS FOR TEMPORARY AND RESTORATION WORK, AND SHALL BE PROVIDED AT NO ADDITIONAL COST TO THE CONTRACT. TEMPORARY ACCESS VIA OTHER AVAILABLE GATES SHALL BE COORDINATED WITH THE PROJECT MANAGER AND SHALL BE PROVIDED FOR BY THE CONTRACTOR AS DIRECTED.
3. CONTRACTOR SHALL BE RESPONSIBLE TO RESTORE ALL GATE FACILITIES AND OPERATIONS BACK TO ORIGINAL CONDITIONS AND AS DIRECTED AT NO ADDITIONAL COST TO THE CONTRACT.
4. CONTRACTOR SHALL COORDINATE ACCESS FOR ALL CONTRACTOR PERSONNEL, VEHICLES, EQUIPMENT, AND DELIVERIES, AND SHALL OBTAIN ALL PERMISSIONS, CLEARANCES, PASSES, ETC. AS REQUIRED FROM THE HAWAII ARMY NATIONAL GUARD. CONSTRUCTION VEHICULAR TRAFFIC SHALL BE ONLY VIA GATES AS DIRECTED BY THE HAWAII ARMY NATIONAL GUARD.
5. CONTRACTOR SHALL COORDINATE WITH THE PROJECT MANAGER DESIGNATION BY THE HAWAII NATIONAL GUARD OF SITE(S) WITHIN THE SECURED AREA FOR THE CONTRACTOR FIELD OFFICE AND BASE YARD.

EROSION/TEMPORARY DUST CONTROL NOTES:

1. DURING CONSTRUCTION, PREVENTIVE MEASURES SHALL BE USED TO CONTROL FORESEEABLE DUST, EROSION OR SEDIMENTATION PROBLEMS WHICH MAY ARISE AS WORK PROGRESSES.
2. FUGITIVE DUST AND SOLID WASTE DISPOSAL DURING GRUBBING AND GRADING ACTIVITIES SHALL MEET THE REQUIREMENTS OF STATE OF HAWAII ADMINISTRATIVE RULES, TITLE 11, CHAPTER 60, AIR POLLUTION CONTROL AND CHAPTER 56, SOLID WASTE MANAGEMENT CONTROL.
3. ALL AREAS WHICH ARE AT FINAL GRADE SHALL BE IMMEDIATELY HYDROMULCHED AND SEEDED WITH COMMON BERMUDA GRASS AT A RATE OF 5 POUNDS PER 1000 SQUARE FEET OR PERMANENTLY LANDSCAPED.
4. ALL EXPOSED AREAS WHICH ARE NOT AT FINAL GRADE AND WHICH ARE TO BE LEFT EXPOSED LONGER THAN 6 WEEKS SHALL BE HYDROMULCHED AND SEEDED WITH COMMON BERMUDA GRASS.
5. REGRASS ALL EXPOSED AREAS.

HAWAII ARMY NATIONAL GUARD ENVIRONMENTAL COMPLIANCE NOTES:

1. IN ORDER TO FACILITATE EMERGENCY PLANNING AND COMMUNITY RIGHT-TO-KNOW ACT (EPCRA) REPORTING REQUIREMENTS, PRIOR TO PROJECT START AND WITHIN 30 DAYS OF COMPLETION OF THE PROJECT, CONTRACTOR SHALL SUBMIT TO HIARNG-ENV A HAZARDOUS MATERIAL INVENTORY LOG OF CHEMICAL PRODUCTS TO BE USED IN THE PROJECT, AND PROVIDE AN UPDATE NO LATER THAN 31 JANUARY OF EACH CALENDAR YEAR. THE LOG SHALL INCLUDE THE PRODUCT NAME AND MANUFACTURER ID NUMBER, CONTAINER SIZE, AMOUNT USED, AND MAXIMUM NUMBER OF CONTAINERS TO BE STORED ON SITE AT ANY GIVEN DAY DURING THE PROJECT. HIARNG-ENV MAY WAIVE THIS REQUIREMENT BASED UPON CONTRACTOR REQUEST. SAFETY DATA SHEETS (SDSs) SHALL BE PROVIDED OR MADE AVAILABLE TO THE PROJECT MANAGER AND HIARNG-ENV UPON REQUEST.
2. PRIOR TO PROJECT START, CONTRACTOR WILL PROVIDE TO HIARNG-ENV AND THE COR/PROJECT MANAGER AN ESTIMATE OF THE MAXIMUM AMOUNT OF HAZARDOUS WASTE, UNIVERSAL WASTE, AND OTHER REGULATED WASTE (E.G., ASBESTOS, LEAD PAINT CHIPS, FLUORESCENT LAMPS, PCB BALLASTS) EXPECTED TO BE GENERATED PER MONTH, AND THE TOTAL AMOUNT ANTICIPATED TO BE STORED ON-SITE AT ANY GIVEN TIME. CONTRACTOR SHALL ALSO PROVIDE NAME OF DISPOSAL/RECYCLING FACILITIES AND TRANSPORTERS TO BE USED FOR HAZARDOUS WASTE, INCLUDING THEIR EPA ID NUMBERS; DISPOSAL/RECYCLING FACILITIES AND TRANSPORTERS USED MUST BE LISTED ON DRMS's LISTS OF QUALIFIED FACILITIES AND QUALIFIED TRANSPORTERS AT <http://www.dispositionservices.dla.mil/newenv/hwdisposal.shtml>. ALL WASTE WILL BE STORED IN A SECURED AREA PENDING REMOVAL FOR DISPOSAL, WITH SIGNAGE INDICATING CONTACT INFORMATION, AND SHALL BE MANAGED, PACKAGED, AND TRANSPORTED IN ACCORDANCE WITH ALL APPLICABLE FEDERAL, STATE, AND LOCAL REGULATIONS. MONTHLY WASTE GENERATION REPORTS SHALL BE PROVIDED TO HIARNG-ENV AND THE PROJECT MANAGER BY THE 5TH OF THE MONTH AFTER THE END OF THE MONTH BEING REPORTED. THE REPORTS SHALL INDICATE THE TYPE OF WASTE AND THE NUMBER OF POUNDS OF EACH TYPE GENERATED IN EACH CONTAINER EACH MONTH.
3. CONTRACTOR SHALL BE RESPONSIBLE FOR ALL COSTS FOR DISPOSAL OF WASTE GENERATED FROM THIS PROJECT AND SHALL PROVIDE COPIES OF ALL WASTE DISPOSAL DOCUMENTATION (INCLUDING ANY REQUIRED LAB ANALYSES, WASTE PROFILES, AND ANY OTHER SUPPORTING DOCUMENTATION) TO THE HIARNG-ENV AND THE PROJECT MANAGER, ALONG WITH DRAFT COPIES OF THE WASTE MANIFESTS FOR REVIEW PRIOR TO WASTE SHIPMENT OFF-SITE FOR DISPOSAL. THE APPLICABLE HIARNG EPA ID NUMBER SHALL BE USED ON WASTE MANIFESTS, AND MANIFESTS WILL ONLY BE SIGNED BY INDIVIDUALS AUTHORIZED BY HIARNG-ENV.

HAWAII ARMY NATIONAL GUARD ENVIRONMENTAL COMPLIANCE NOTES (CONTINUED):

4. ALL CONSTRUCTION SITES ARE SUBJECT TO THE REGULATIONS OF 40 CFR 112 OIL POLLUTION PREVENTION AND ARE REQUIRED TO PREPARE A SITE SPECIFIC SPILL PREVENTION, CONTROL AND COUNTERMEASURE (SPCC) PLAN IF STORING MORE THAN 1320 GALLONS (G) OF POL ON SITE. A COPY OF THE SPCC PLAN MUST BE SUBMITTED TO HIARNG-ENV BEFORE START OF THE PROJECT AND KEPT READILY AVAILABLE ON SITE. IF THE SITE IS STORING LESS THAN 1320 G OF POL NO SPCC PLAN IS REQUIRED, HOWEVER, THE CONTRACTOR SHALL IMPLEMENT THE APPLICABLE HIARNG SPCC PLAN.
5. CONTRACTOR, IN GENERAL, SHALL BE RESPONSIBLE FOR ASSESSING WHETHER THE PROJECT AND/OR PROJECT ACTIVITIES REQUIRE ENVIRONMENTAL PERMITS AND ARE RESPONSIBLE FOR OBTAINING, IMPLEMENTING AND MAINTAINING ALL APPLICABLE PERMIT REQUIREMENTS.
6. ALL PROJECTS THAT DISTURB MORE THAN 1 ACRE OF SOIL, INCLUDING PROJECTS THAT, CONSIDERED WITH OTHER RELATED PROJECTS (I.E., ARE PART OF A LARGER COMMON PLAN OF DEVELOPMENT OR SALE), CUMULATIVELY DISTURB MORE THAN 1 ACRE OF SOIL, ARE REQUIRED TO OBTAIN AN APPLICABLE POLLUTANT DISCHARGE ELIMINATION SYSTEM (NPDES) STORMWATER DISCHARGE PERMIT FROM THE HAWAII DEPARTMENT OF HEALTH (HDOH) AND IMPLEMENT ALL PERMIT REQUIREMENTS, PLANS, AND INSPECTIONS. SITES LESS THAN 1 ACRE ARE REQUIRED TO IMPLEMENT BEST MANAGEMENT PRACTICES (BMP'S) TO PREVENT CONTAMINATED STORMWATER FROM LEAVING THE SITE.
7. CONTRACTORS SHALL BE RESPONSIBLE FOR DETERMINING THE NEED FOR AND OBTAINING ANY ALL REQUIRED ENVIRONMENTAL PERMITS, E.G. NPDES PERMITS FOR CONSTRUCTION ACTIVITY, UNDERGROUND INJECTION CONTROL WELL (UIC), COUNT-REQUIRED INDUSTRIAL WASTEWATER DISCHARGE PERMITS, MINOR POLLUTION SOURCE AIR PERMITS, ETC. FOR ANY CONTRACT-RELATED WORK. THE HIANG ENV OFFICE SHALL BE COPIED ON ALL PERMIT CORRESPONDENCE, AND SHALL BE PROVIDED THE ORIGINAL COPY OF ALL PERMITS.
8. CONTRACTORS ARE REQUIRED TO INSTALL AND MAINTAIN STORMWATER BEST MANAGEMENT PRACTICES (BMPs) AND PROTECTIVE MEASURES (REGARDLESS OF PROJECT SIZE OR SCOPE) TO PREVENT THE POLLUTION OF STORMWATER TO THE MAXIMUM EXTENT PRACTICABLE (MEP).
9. CONTRACTOR SHALL BE RESPONSIBLE FOR COMPLYING WITH ALL EXISTING AND APPLICABLE HIARNG ENVIRONMENTAL PERMITS, E.G., NATIONAL POLLUTANT DISCHARGE ELIMINATION SYSTEM (NPDES) PERMITS, UIC PERMITS, INDUSTRIAL WASTEWATER DISCHARGE PERMITS (IWDPs), INDIVIDUAL WASTEWATER SYSTEM (WWS) PERMITS, ETC.
10. CONTRACTOR SHALL POST EMERGENCY CONTACT SIGN INDICATING THE NAME AND PHONE NUMBER FOR THE PROJECT MANAGER, THE CONTRACTOR EMERGENCY CONTACT, POLICE/FIRE DEPARTMENT 911, AND HIARNG ENV 672-1013. CONTRACTOR SHALL REPORT SPILLS IMMEDIATELY TO THE COR AND HIARNG-ENV AND COMPLETE THE HIARNG SPILL INCIDENT REPORT FORM AS REQUIRED. CONTRACTOR SHALL IMMEDIATELY CLEAN UP ALL SPILLS IAW FEDERAL AND STATE GUIDELINES AND TO THE SATISFACTION OF HIARNG-ENV. CONTRACTOR SHALL MAINTAIN ADEQUATE SPILL SUPPLIES COMMENSURATE WITH THE POTENTIAL FOR SPILLS, AND WILL CONTRACT OUT SPILL CLEANUP BEYOND THEIR CAPABILITIES. CONTRACTOR SHALL ACCOMPLISH ALL REGULATORY VERBAL AND WRITTEN NOTIFICATIONS TO THE STATE EMERGENCY RESPONSE COMMISSION, LOCAL EMERGENCY PLANNING COMMITTEE (LEPC), NATIONAL RESPONSE CENTER (NRC), ENVIRONMENTAL PROTECTION AGENCY (EPA), AS APPLICABLE, AND PROVIDE HIARNG-ENV COPIES OF ALL SPILL REPORTS SUBMITTED.
11. SEND TO HIARNG-ENV THE DATA FOR NON-HAZARDOUS RECYCLED/DIVERTED WASTE (I.E. WASTE THAT DOES NOT GO INTO THE LANDFILL OR H-POWER) AND NON-HAZARDOUS DISPOSED WASTE FOR ALL CONSTRUCTION PROJECTS. DATA CAN BE PROVIDED BY ANY MEANS (E.G. RECEIPT COPIES, EXCEL TABLE, EMAIL MESSAGE)

DATA SHOULD INCLUDE:

RECYCLED/DIVERTED WASTE

- TYPE OF MATERIAL
- NET WEIGHT
- RECYCLE FACILITY (E.G. SCHNITZER, ISLAND RECYCLING, REFRIGERANT RECYCLING)
- TICKET NUMBER (IF AVAILABLE)
- COST/REVENUE (IF APPLICABLE)

DISPOSED WASTE

- NET WEIGHT
- DISPOSAL FACILITY (E.G. PVT, SCHNITZER)
- TICKET NUMBER (IF AVAILABLE)
- COST (IF APPLICABLE)

HAWAII ARMY NATIONAL GUARD SOLID WASTE CONSTRUCTION NOTES:

1. THE CONTRACTOR SHALL SUBMIT SOLID WASTE REPORTS TO THE HIARNG PROJECT MANAGER FOR THE DURATION OF THE PROJECT. THE REPORTS SHALL ADDRESS:
 - A. DIVERTED WASTE (I.E. WASTE THAT DOES NOT GO INTO LANDFILL)
 - B. RECYCLED WASTE
 - C. LANDFILL WASTE
 - D. RECOVERED WASTE (I.E. FREON FROM AC EQUIPMENT AND REFRIGERATORS)
2. THE CONTRACTOR SHALL SUBMIT LEGIBLE COPIES OF DUMP TICKET RECEIPT FROM VENDOR SHOWING THE TONNAGE OF WASTE TO THE HIARNG PROJECT MANAGER. IF WASTE PRODUCTS ARE COMBINED WITH OTHER PROJECTS, THE CONTRACTOR SHALL PROVIDE A BREAKDOWN PER PROJECT.

SLOPE CLEARING NOTES:

1. THE CONTRACTOR SHALL BE RESPONSIBLE FOR CLEARING OF TREES, BRUSH, AND OTHER VEGETATION ON THE SOUTHWEST SLOPE OF THE HIARNG PROPERTY. CLEARING SHALL BE WITHIN THE HIARNG PROPERTY.
2. TREES, STUMPS, ROOTS, BRUSH AND OTHER VEGETATION SHALL BE CUT OFF FLUSH WITH THE ORIGINAL GROUND SURFACE.
3. CLEARED MATERIAL FROM THE HIARNG PROPERTY SHALL BECOME PROPERTY OF THE CONTRACTOR, AND SHALL BE REMOVED FROM THE HIARNG PROPERTY AND DISPOSED OF IN ACCORDANCE WITH APPLICABLE LOCAL AND STATE LAWS.



A/E INFO



SEAL

APPR

DATE

DESCRIPTION

SYM

SUBMITAL PHASE

FINAL

SUBMITAL DATE

03/02/15

DES

ET

DRW

BTY

CHK

RA

DEPARTMENT OF DEFENSE

DESIGN AND PROJECT

MANAGEMENT BRANCH

HONOLULU, HAWAII

HAWAII ARMY NATIONAL GUARD

PHYSICAL SECURITY AND IMPROVEMENTS

WAIAWA PERIMETER FENCE

STATE OF HAWAII

FACILITY MANAGEMENT OFFICE

HIARNG

GENERAL NOTES, SHEET 2

SCALE:

AS NOTED

STATE JOB NO.

CA-1328-0


FEDERAL PROJECT NO.

15140023

SHEET

4 OF 25

G-04

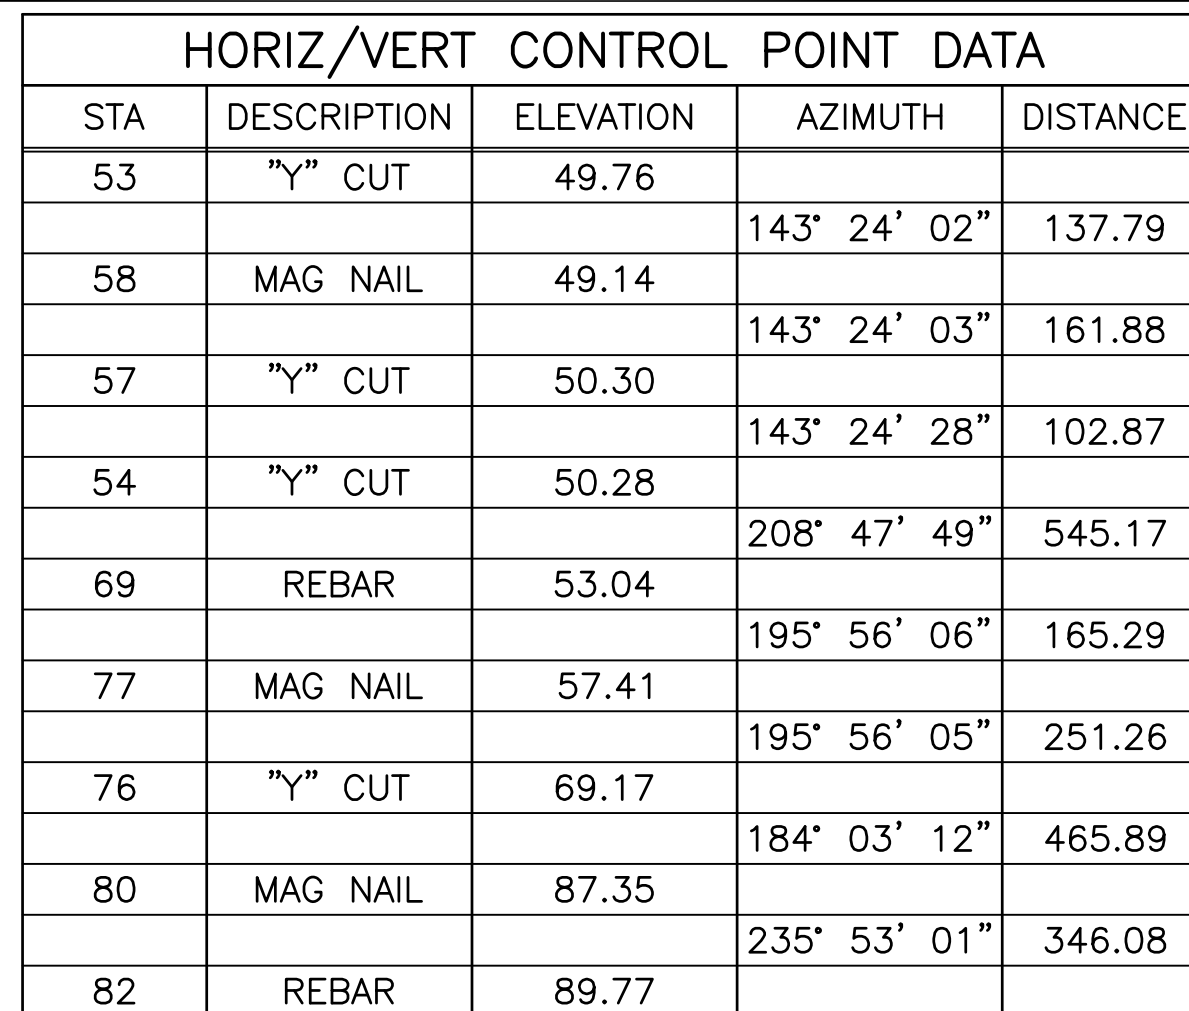

HORIZ/VERT CONTROL POINT DATA				
STA	DESCRIPTION	ELEVATION	AZIMUTH	DISTANCE
82	REBAR	89.77		
			331° 59' 55"	390.59
83	MAG NAIL	85.55		
			354° 19' 01"	411.35
59	"Y" CUT	69.50		
			24° 06' 37"	166.22
60	"Y" CUT	61.03		
			24° 06' 37"	228.61
61	"Y" CUT	54.44		
			24° 06' 37"	309.05
55	1/2" PIPE	51.27		
			33° 24' 57"	215.23
56	"+" CUT	48.94		
			44° 01' 38"	394.95
53	"Y" CUT	49.76		

HORIZ/VERT CONTROL POINT DATA				
STA	DESCRIPTION	ELEVATION	AZIMUTH	DISTANCE
57	"Y" CUT	50.30		
			212° 11' 54"	274.53
67	"Y" CUT	51.16		
			301° 37' 07"	178.63
68	MAG NAIL	50.22		
			212° 44' 47"	300.20
62	MAG NAIL	53.15		
			326° 35' 16"	201.39
55	1/2" PIPE	51.27		
			33° 24' 57"	215.23
56	"+" CUT	48.94		
			44° 01' 38"	394.95
53	"Y" CUT	49.76		
			143° 24' 02"	137.79
58	MAG NAIL	49.14		
			143° 24' 03"	161.88
57	"Y" CUT	50.30		

HORIZ/VERT CONTROL POINT DATA				
STA	DESCRIPTION	ELEVATION	AZIMUTH	DISTANCE
76	"Y" CUT	69.17		
			205° 06' 41"	415.29
75	REBAR	79.72		
			210° 59' 37"	286.98
79	MON SPIKE	86.06		
			15° 25' 46"	176.42
81	MAG NAIL	84.05		
			291° 04' 52"	166.87
87	HUB	—		
			291° 04' 52"	241.29
59	"Y" CUT	69.50		
			174° 19' 01"	411.35
83	MAG NAIL	85.55		
			151° 59' 55"	390.59
82	REBAR	89.77		
			55° 53' 01"	346.08
80	MAG NAIL	87.35		
			4° 03' 12"	465.89
76	"Y" CUT	69.17		



SCALE: 1" = 80'

LEGEND:

 40' SCALE SHEET LOCATION

GRAPHIC SCALE:



SCALE: 1" = 80'

SUBMITTAL PHASE				
FINAL				
SUBMITTAL DATE			03/02/19	
DES	ET	DRW	RTY	CHK

DEPARTMENT OF DEFENSE DESIGN AND PROJECT MANAGEMENT BRANCH	HONOLULU, HAWAII
--	------------------

WAIJAWA
PERIMETER FENCE

STATE OF HAWAII
FACILITY MANAGEMENT OFFICE
HIARNIG

SCALE: AS NOTED


STATE JOB NO.
CA-1328-D

FEDERAL PROJECT NO.
15140023

SHEET 5 OF 25

G-05

1
2
3
4
5
D
C
B
A

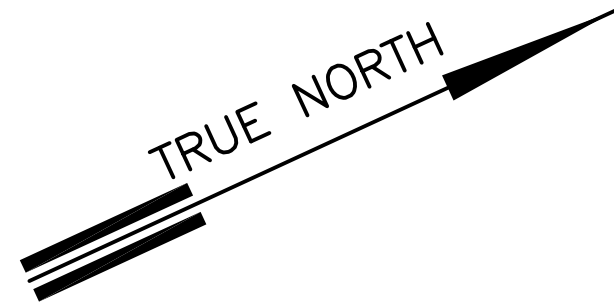

POR. R.P. 4475, L.C. AW. 7713,
APANA 46 TO V. KAHAMALU
T.M.K.: 9-6-4: 24

BUILDING 21

WAIAWA NATIONAL GUARD
STORAGE AREA
19.217 ACS.

BUILDING 22

BUILDING

BUILDING 1

WAIHONA
STREET

LOT A
T.M.K.: 9-6-7: 1

LOT 6
(F.P. 1461)
T.M.K.: 9-6-7: 6


LOT 7
(F.P. 1461)
T.M.K.: 9-6-7: 7

PROPERTY LINE

MATCH LINE - SEE SHEET G-07

EXISTING CONDITIONS PLAN
SCALE: 1" = 40'

GRAPHIC SCALE:

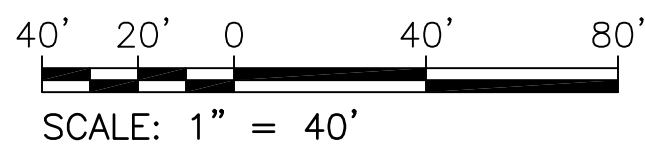

HR

A/E INFO



SEAL

APPR

DATE

DESCRIPTION

SYM

SUBMITTAL PHASE
FINAL

SUBMITTAL DATE: 03/02/15
DES ET DRW BTY CHK RA

DEPARTMENT OF DEFENSE
DESIGN AND PROJECT
MANAGEMENT BRANCH
HONOLULU, HAWAII

HAWAII ARMY NATIONAL GUARD
PHYSICAL SECURITY AND IMPROVEMENTS
WAIAWA
PERIMETER FENCE
EXISTING CONDITIONS PLAN, SHEET 1

STATE OF HAWAII
FACILITY MANAGEMENT OFFICE
HIARNG

SCALE: AS NOTED

STATE JOB NO. CA-1328-D

FEDERAL PROJECT NO. 15140023

SHEET 6 OF 25

 
G-06

FILE: 2013033-106
DATE: 01/03/14

OPER: WFA
DATE REV: 02/16/15



W A I H O N A S T R E E T



LOT 12
 (F.P. 1461)
 T.M.K.: 9-6-7: 12

EXISTING CONDITIONS PLAN

SCALE: 1" = 40'

LOT 38
(F.P. 1461)
T.M.K.: 9-6-8: 25

LOT 39
(F.P. 1461)
T.M.K.: 9-6-8: 26

BUILDING 65

[illegible]


SUBMITTAL PHASE					
FINAL					
SUBMITTAL DATE				03/02/15	
DES	ET	DRW	BTY	CHK	RA

STATE OF HAWAII	DEPARTMENT OF DEFENSE
FACILITY MANAGEMENT OFFICE	DESIGN AND PROJECT MANAGEMENT BRANCH
HIARIG	HONOLULU, HAWAII
HAWAII ARMY NATIONAL GUARD PHYSICAL SECURITY AND IMPROVEMENTS	
WAIJAWA PERIMETER FENCE	
EXISTING CONDITIONS PLAN, SHEET 3	

SCALE:	AS NOTED	
STATE JOB NO.	CA-1328-D	
FEDERAL PROJECT NO.	15140023	
SHEET	8	OF 25
G-08		

40' 20' 0 40' 80'

SCALE: 1" = 40'

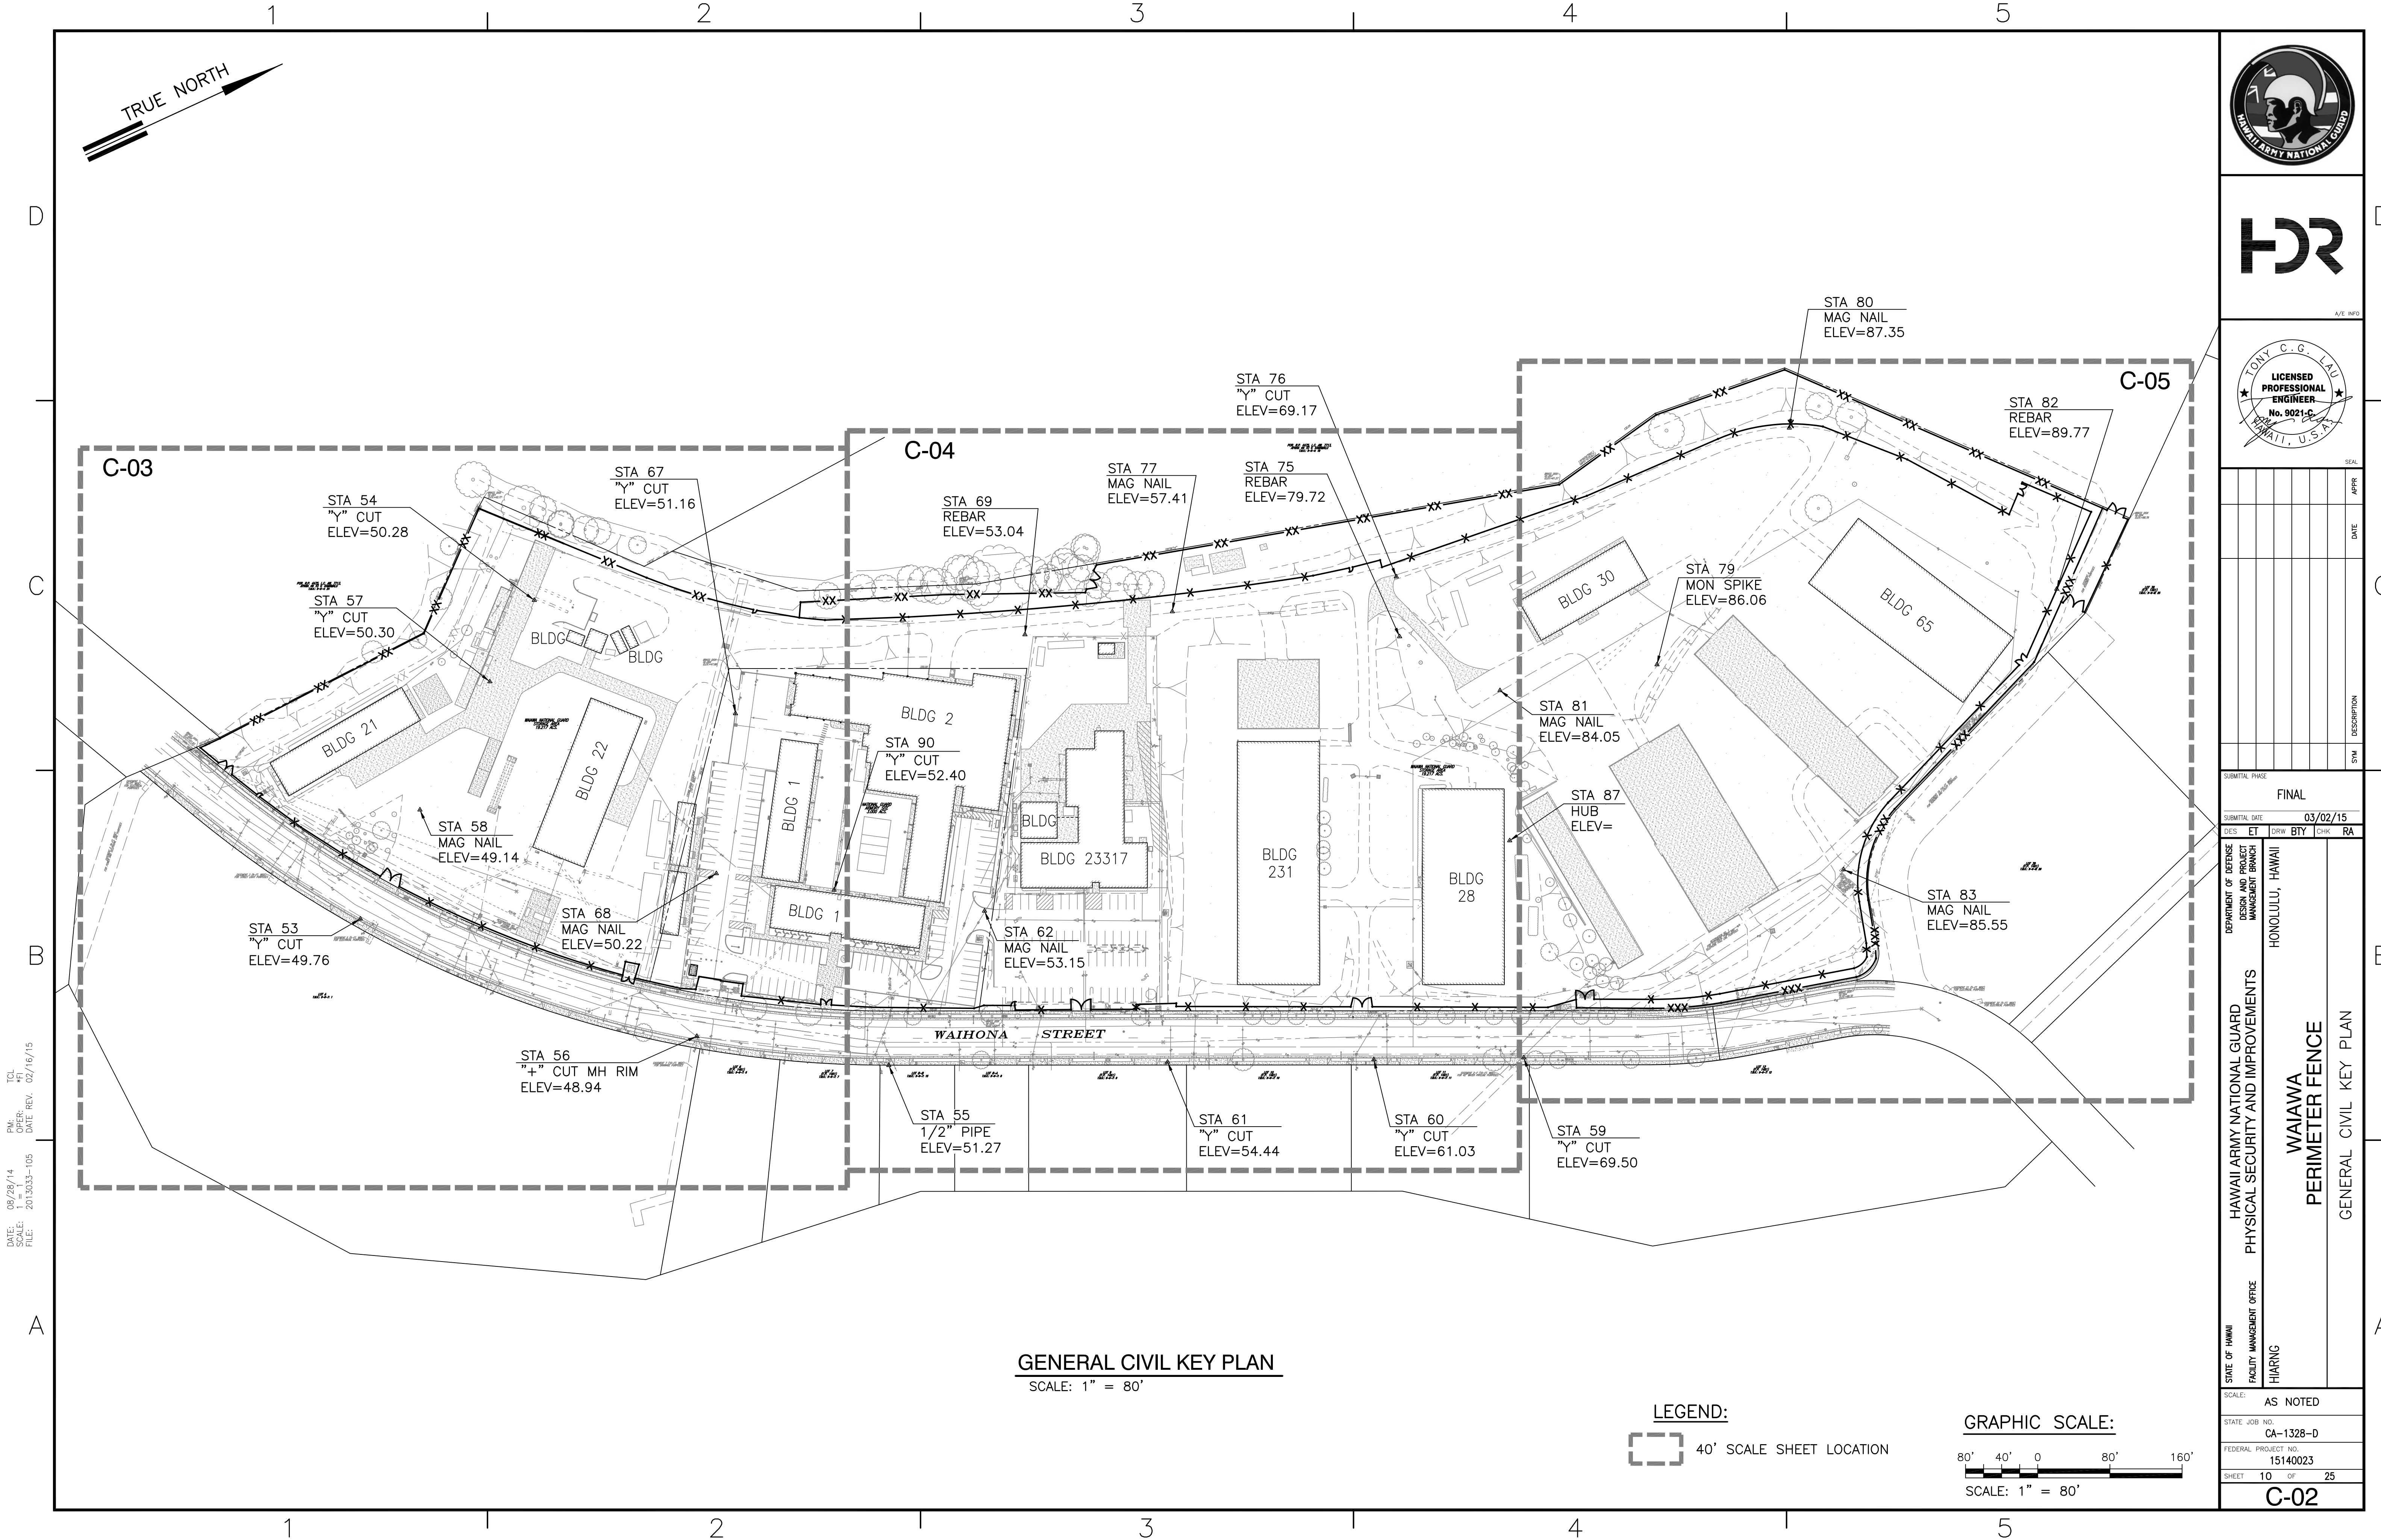

DATE: 08/28/14
SCALE: 1" = 80'
FILE: 2013033-105

TCL
PM: 02/16/15


OFFER REV. 02/16/15
DATE REV. 02/16/15

GENERAL CIVIL KEY PLAN
SCALE: 1" = 80'

LEGEND:

40' SCALE SHEET LOCATION

GRAPHIC SCALE:

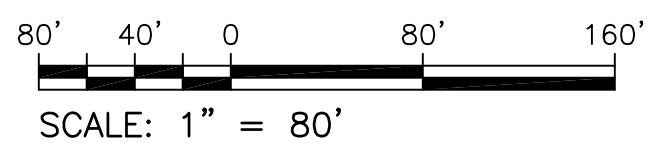

SCALE: 1" = 80'



DATE	DESCRIPTION	BY	CHK	RA
03/02/15	DESIGN AND PROJECT MANAGEMENT BRANCH	DES	ET	BTY

SUBMITAL PHASE: FINAL

SUBMITAL DATE: 03/02/15

DESIGN AND PROJECT MANAGEMENT BRANCH

HONOLULU, HAWAII

STATE OF HAWAII

FACILITY MANAGEMENT OFFICE

HAWAII ARMY NATIONAL GUARD

PHYSICAL SECURITY AND IMPROVEMENTS

WAIAWA PERIMETER FENCE

GENERAL CIVIL KEY PLAN


HIARNG


STATE JOB NO. CA-1328-D

FEDERAL PROJECT NO. 15140023


SHEET 10 OF 25

C-02

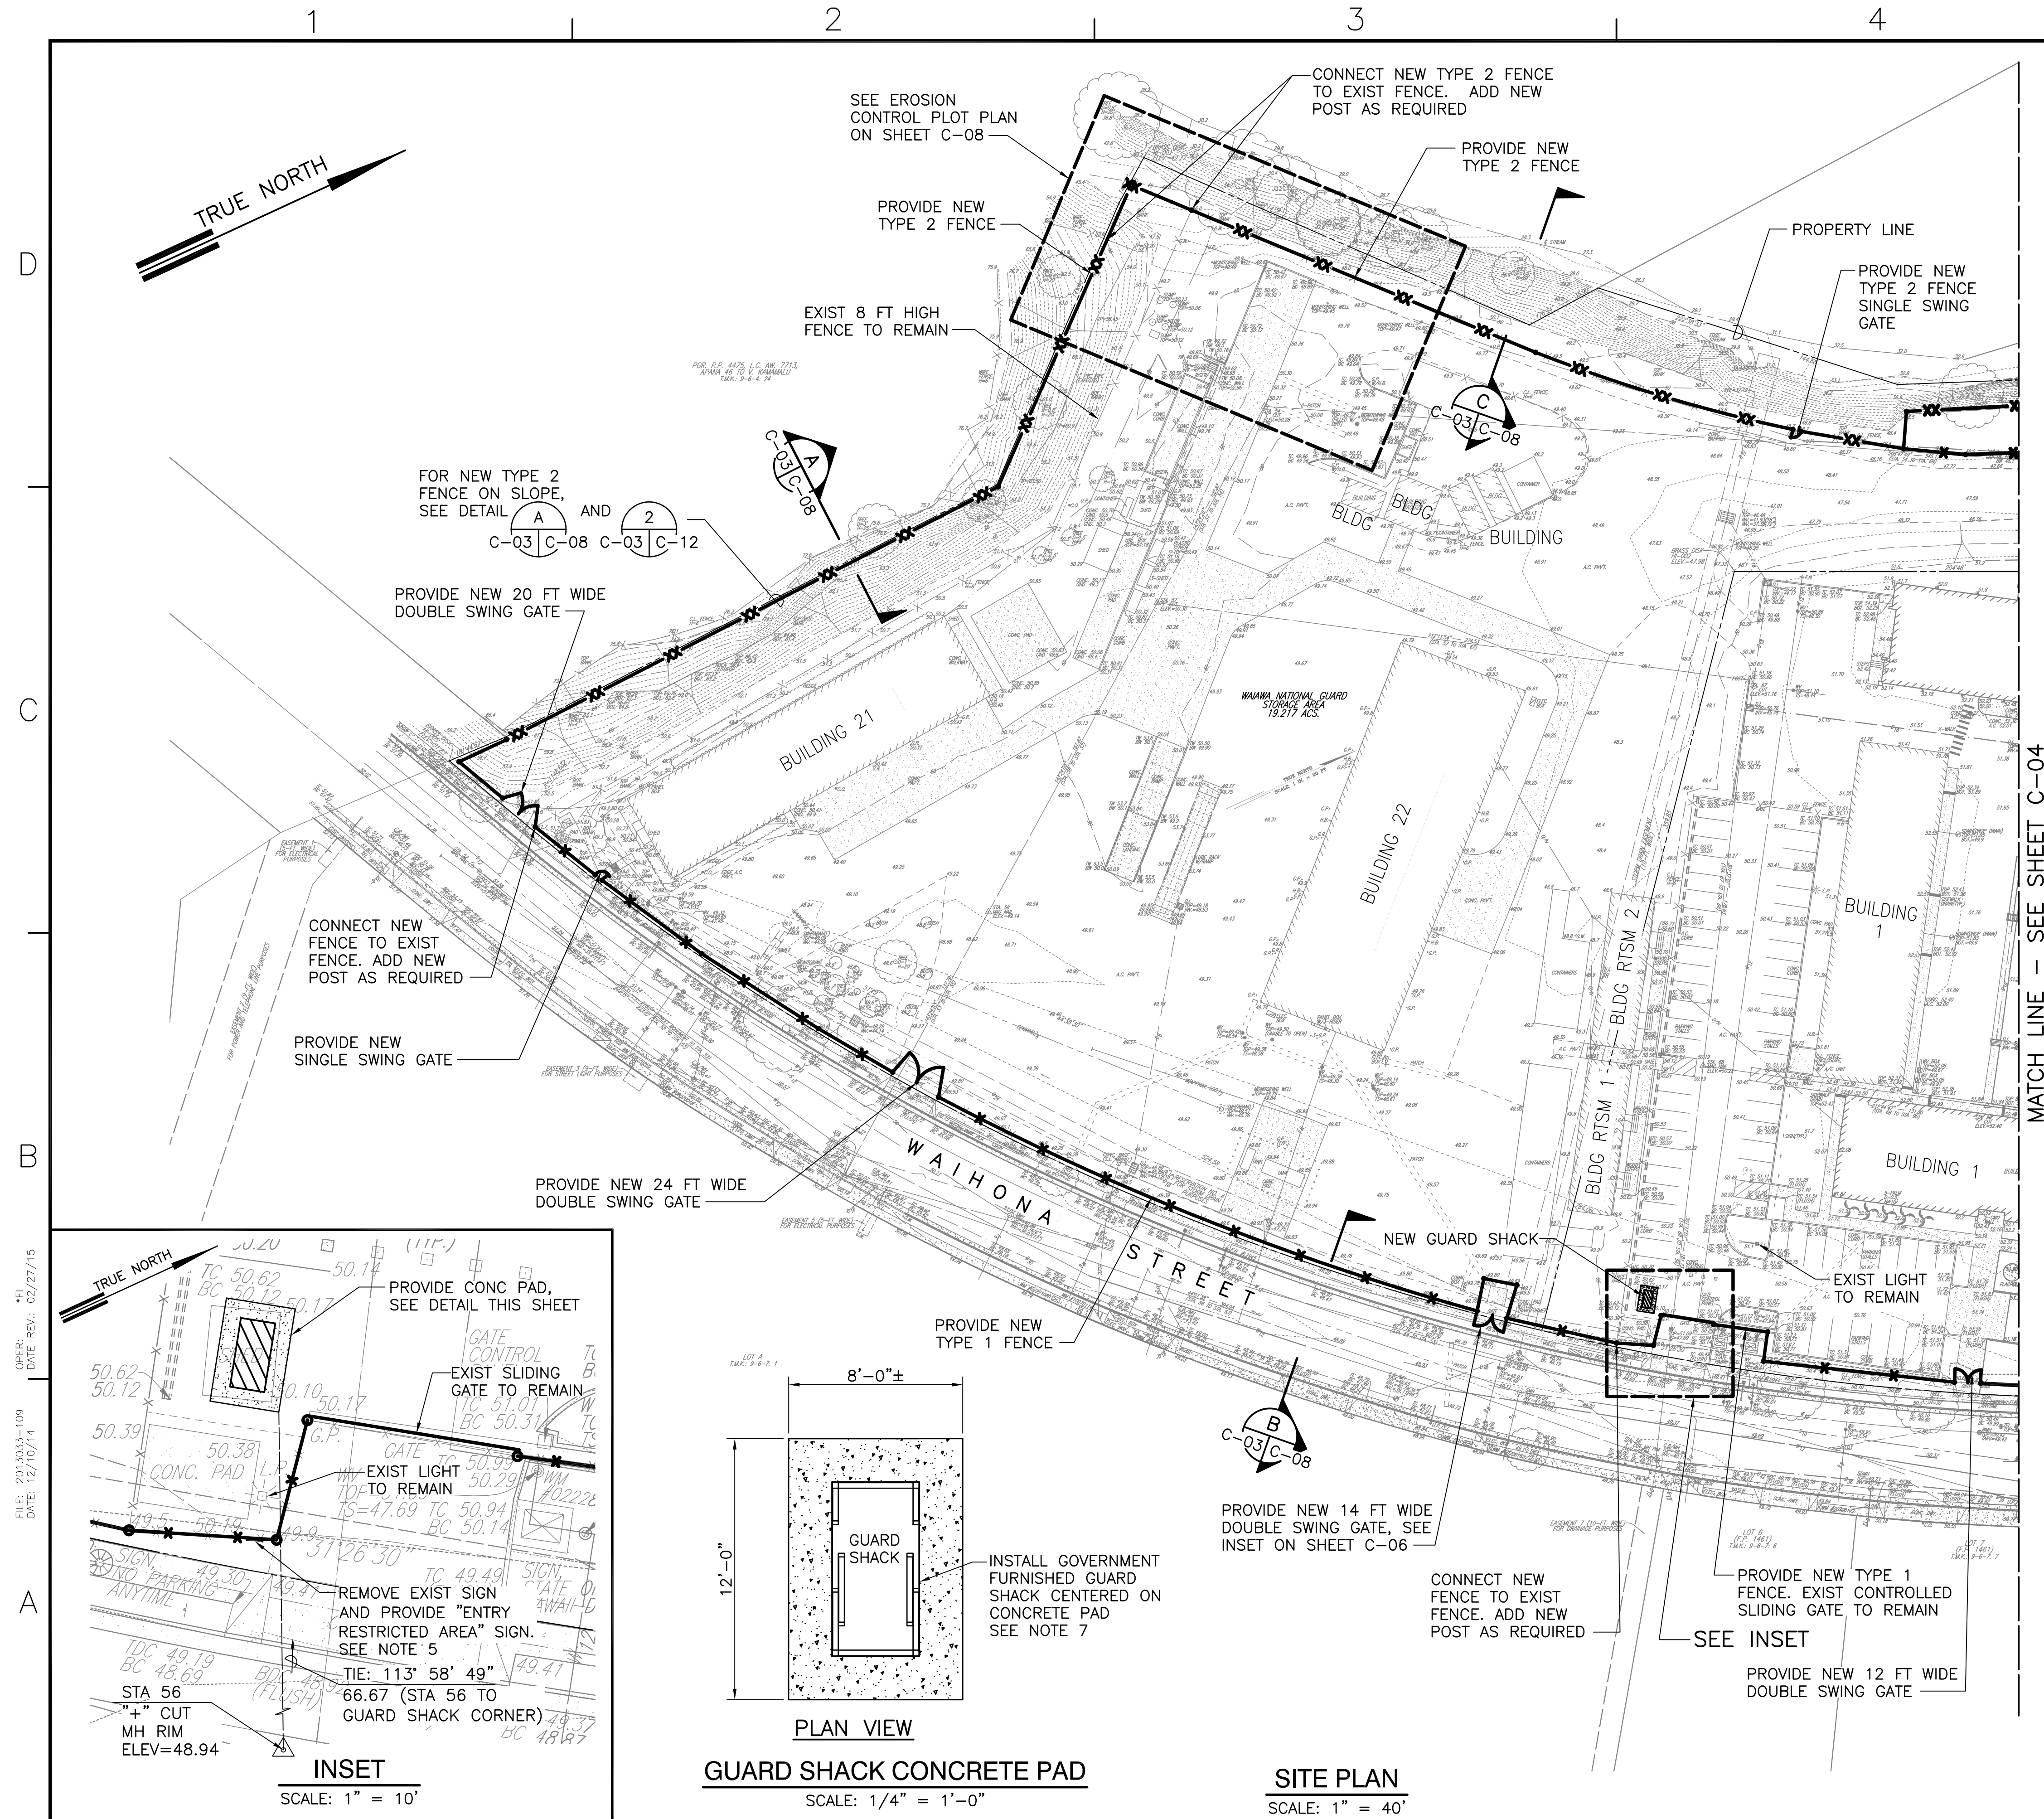

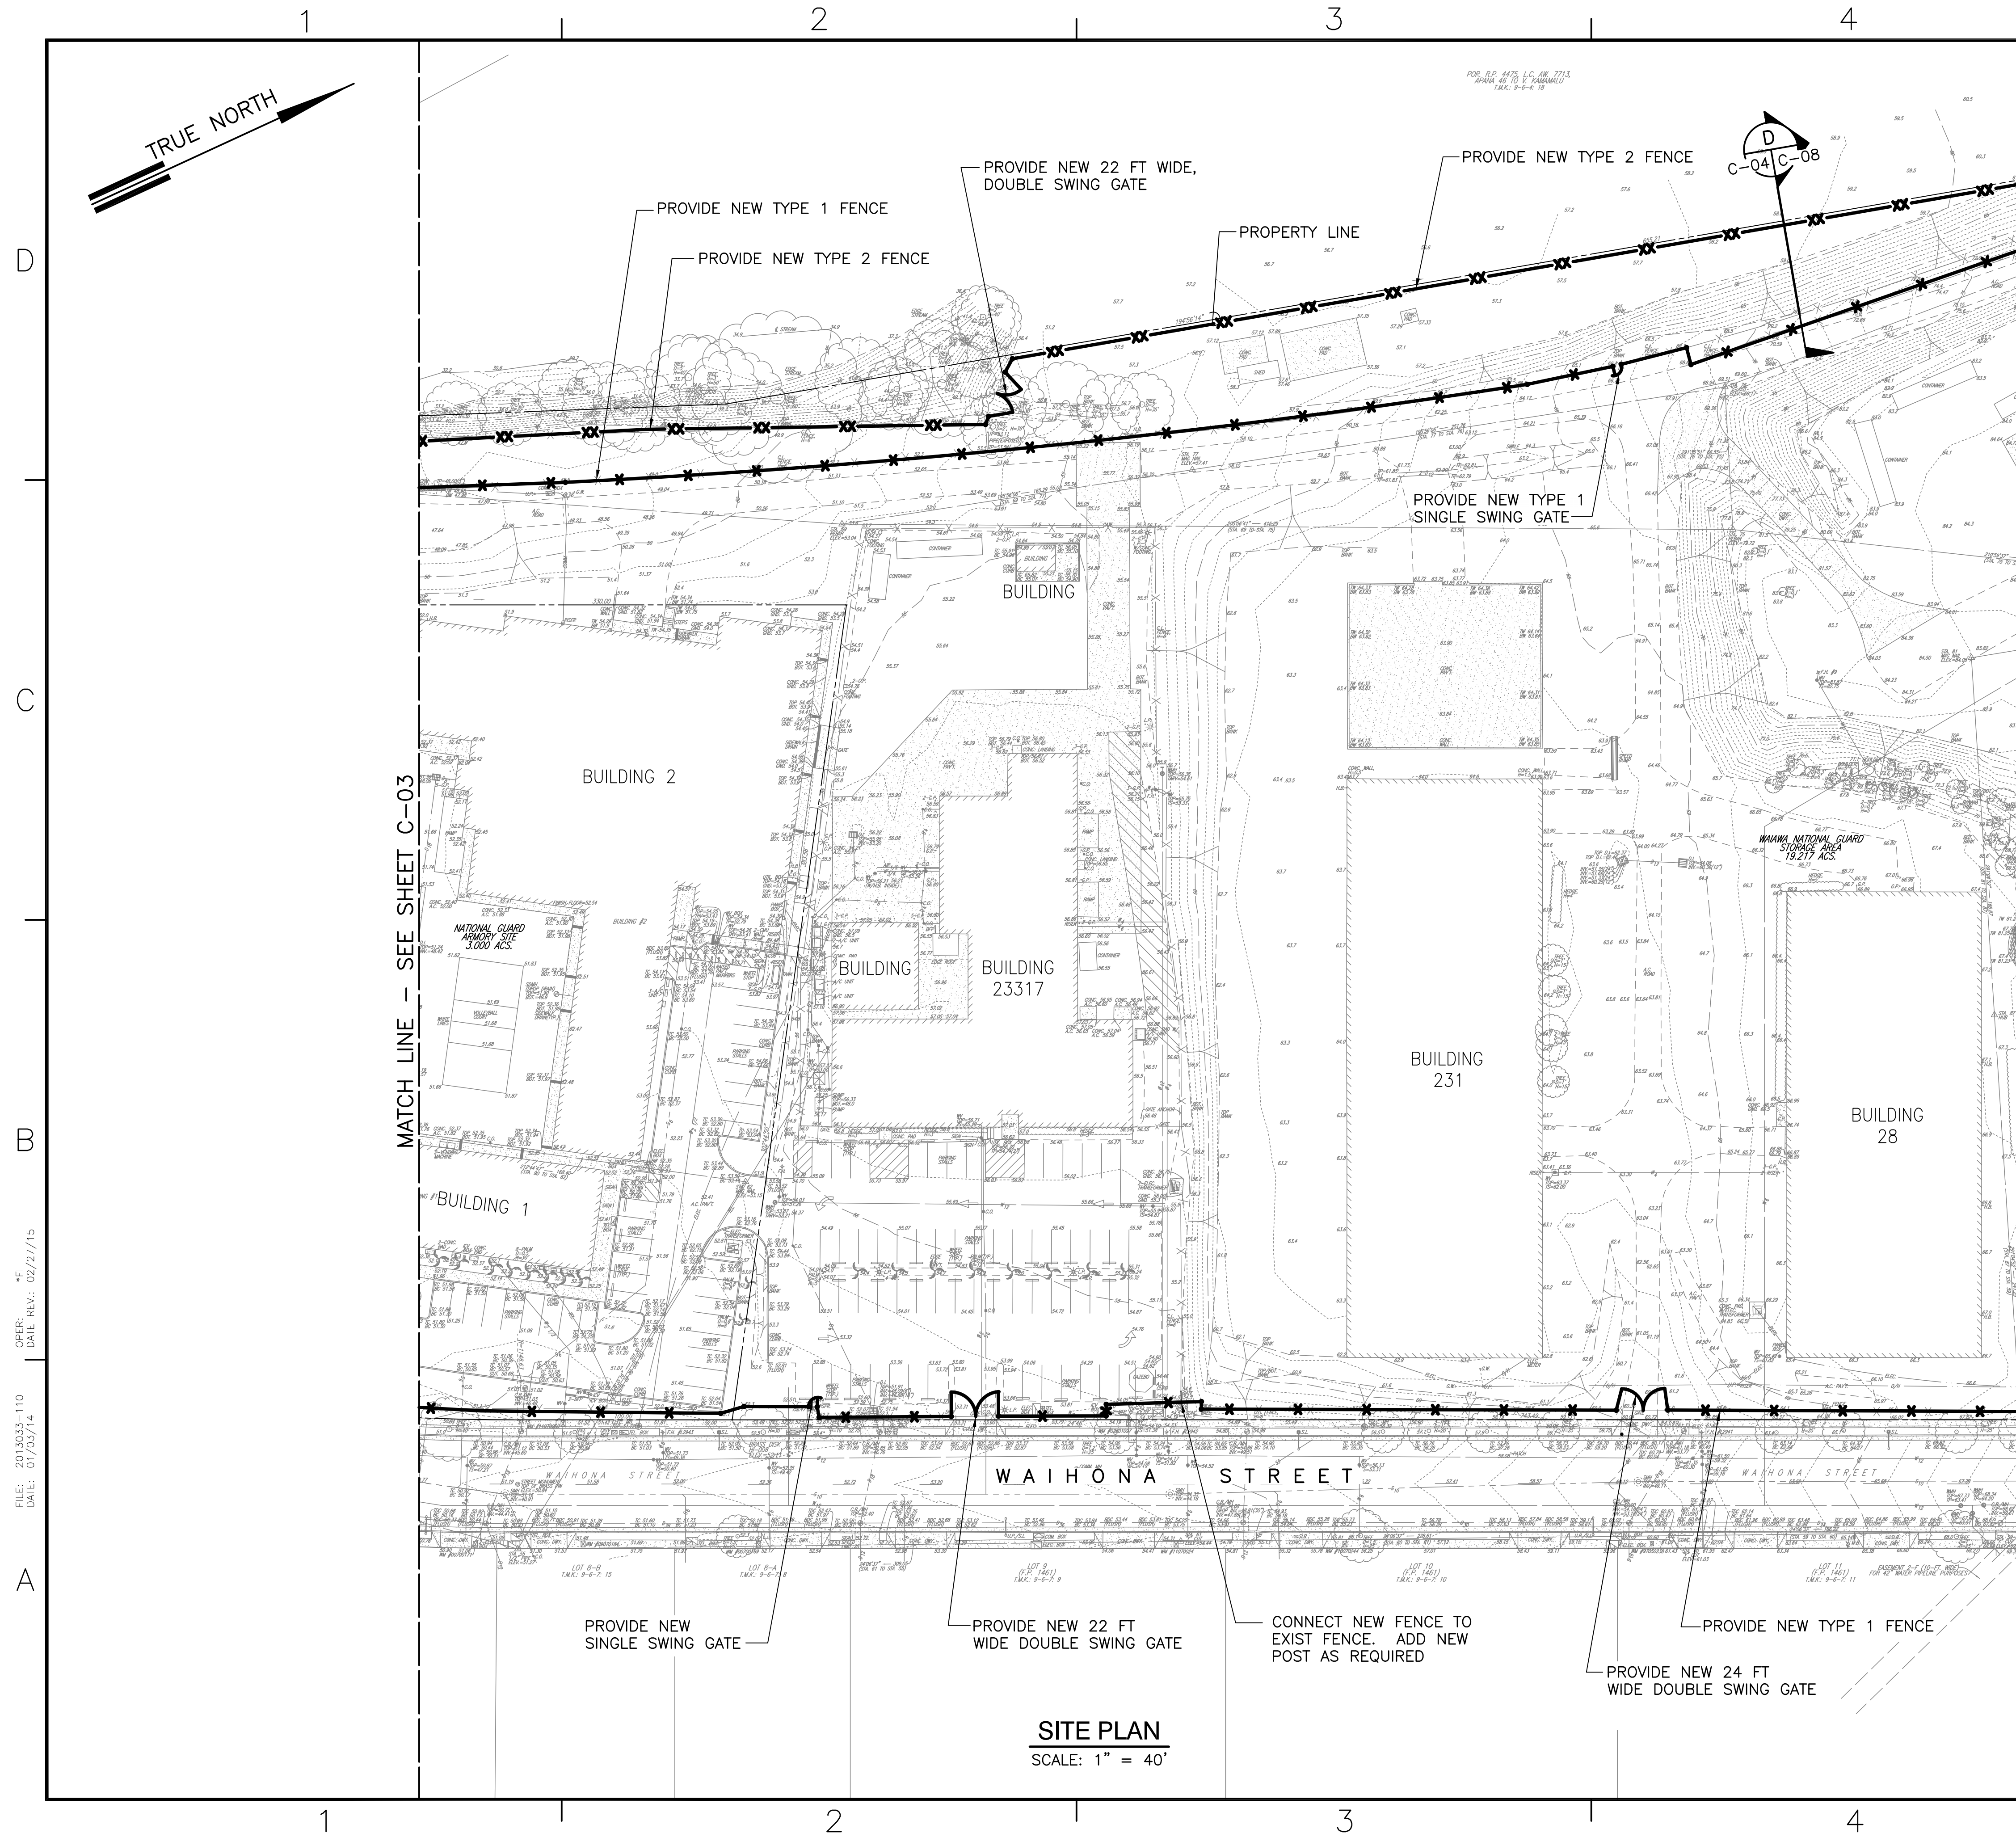

A/E INF

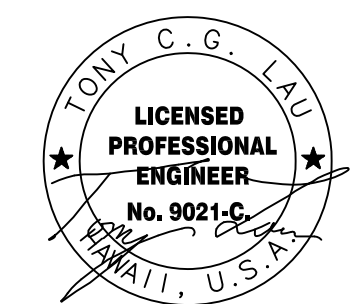

SEA

88

31

	NO
--	----

SYN

SUBMITTAL PHASE

FINAL

SUBMITTAL DATE 03/02/15

DES	ET	DRW	RTY	CHK	RA
-----	----	-----	-----	-----	----

100	100	100	100
100	100	100	100

All

DEFERRED PROPOSAL AWARD

OF	ID F	NT	H.
----	------	----	----

U,

JULI

PART
DES
MAI

DEF	CONC
-----	------

HC

[illegible]

60			
----	--	--	--


SL

	N		
--	---	--	--

CDME







313



2


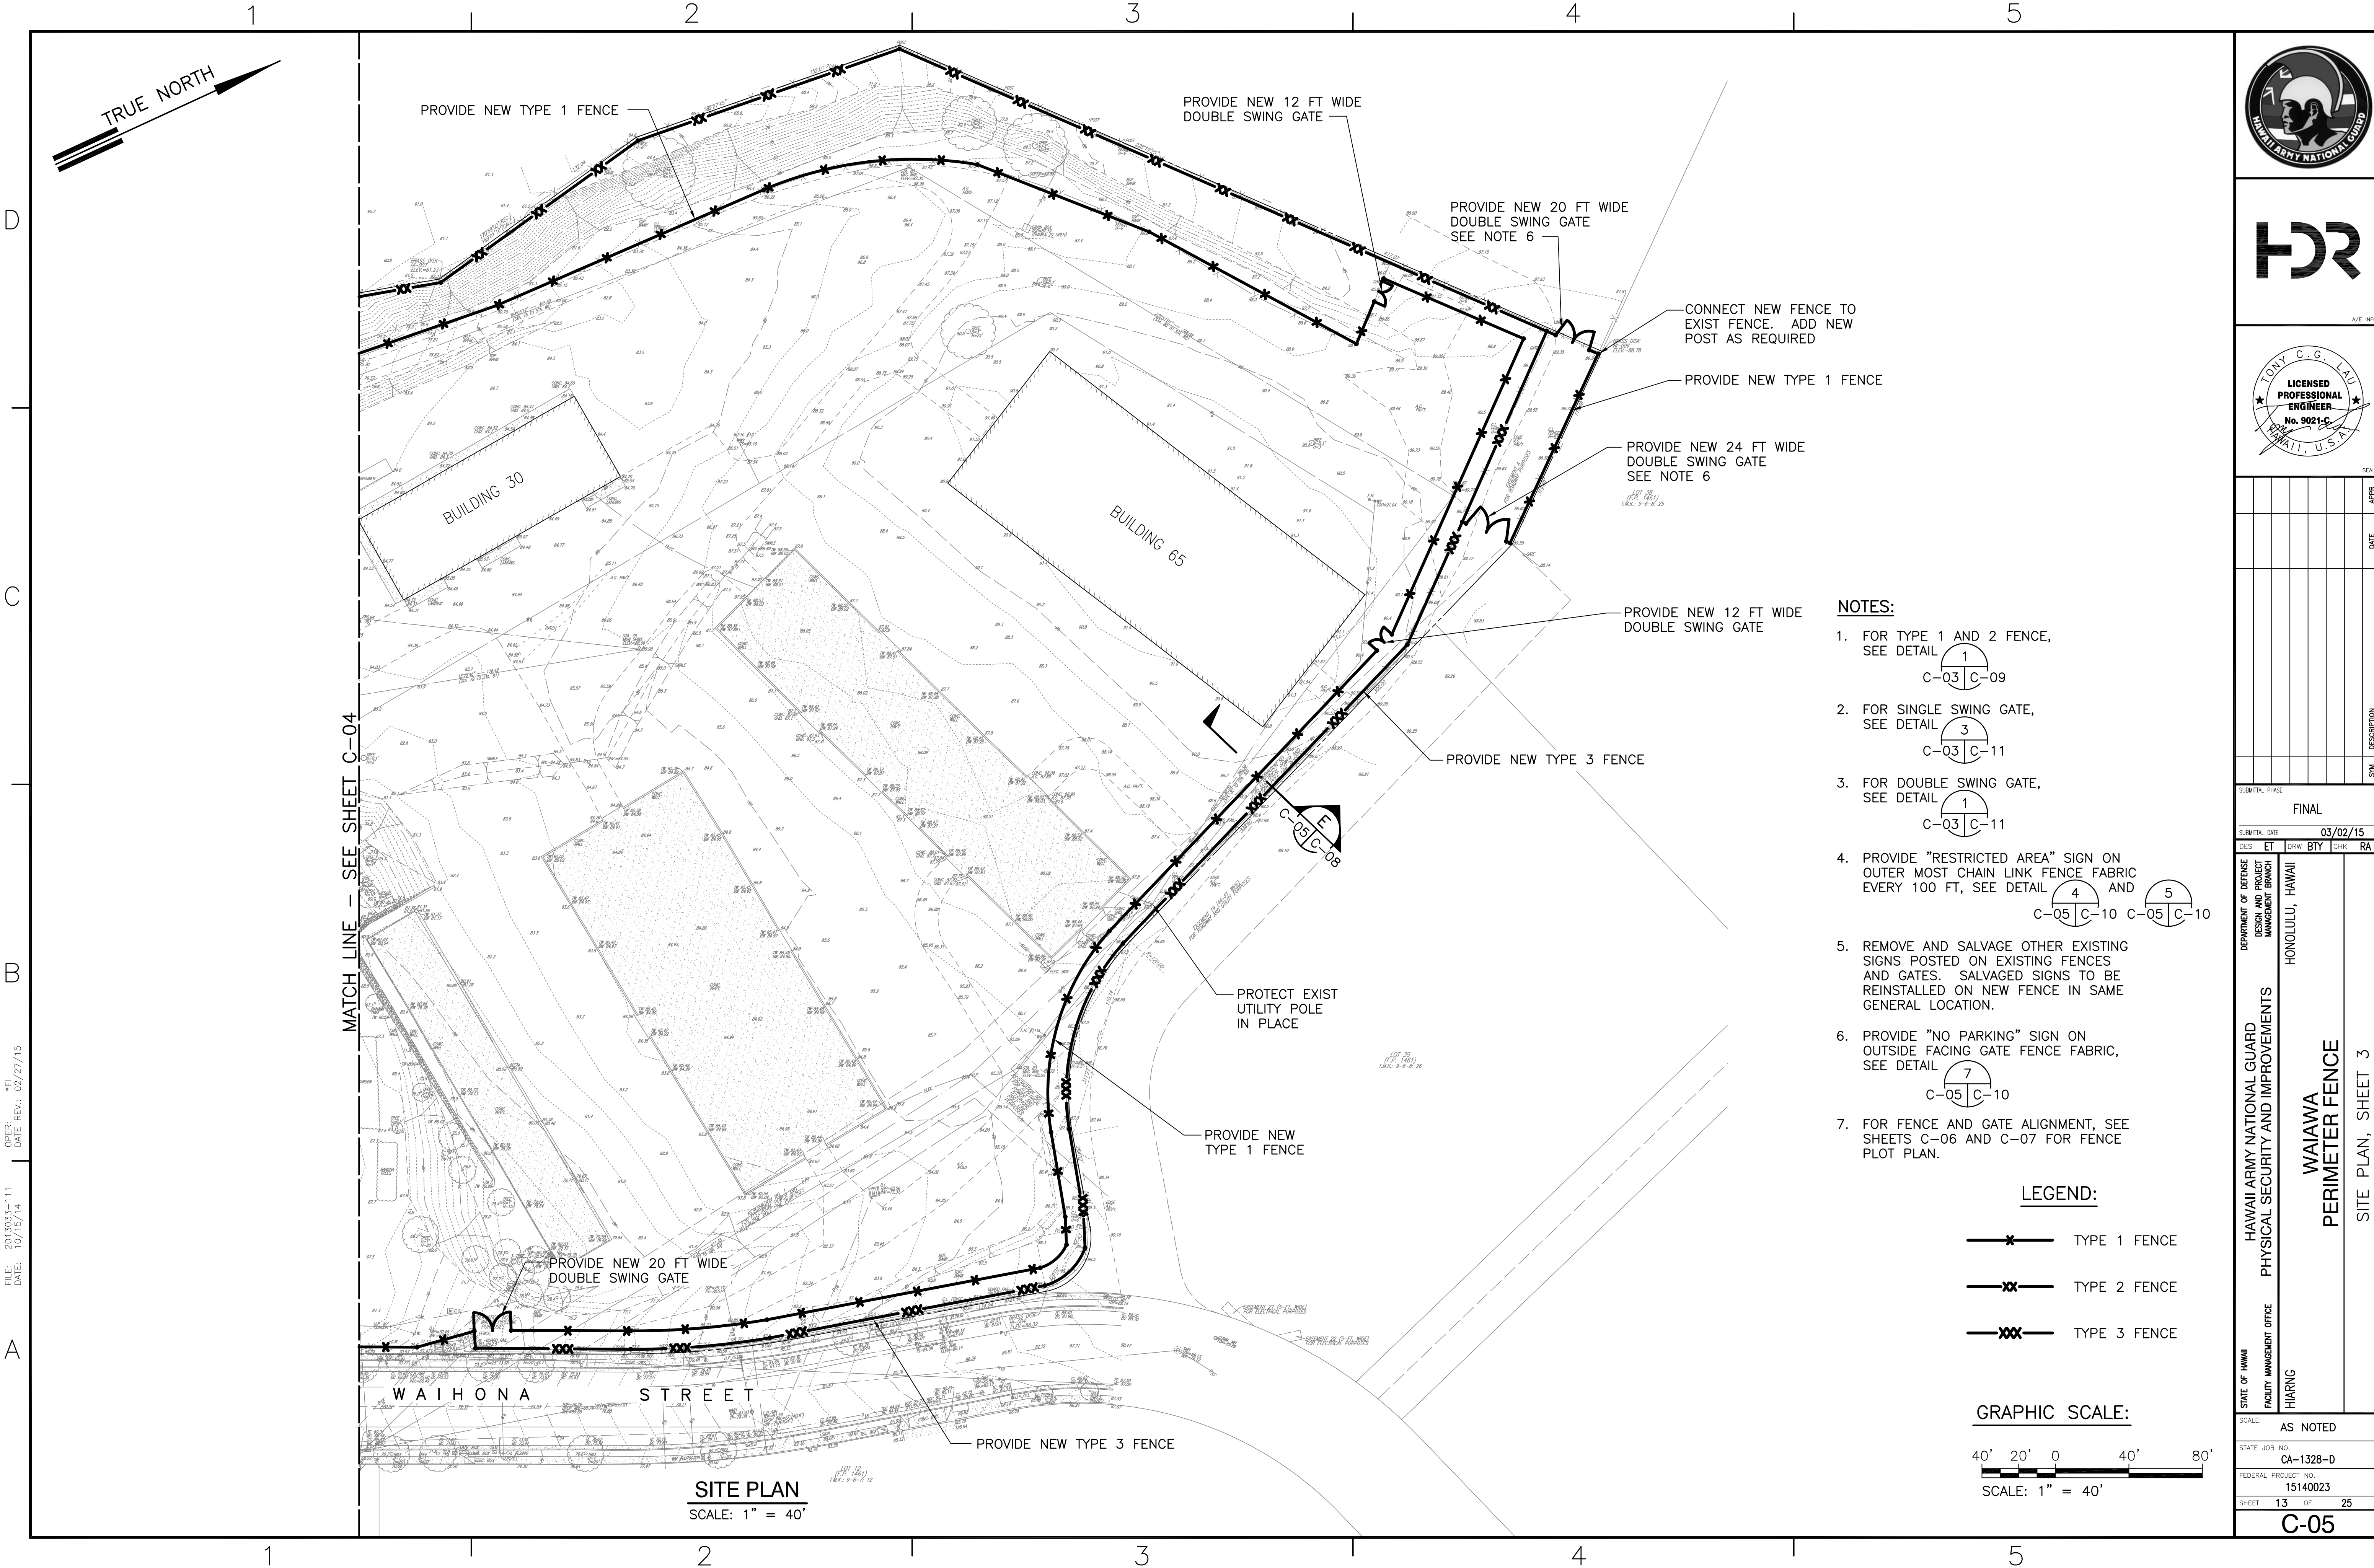


FILE: 2013033-111
DATE: 10/15/14
OPER: *FI
DATE REV: 02/27/15

SITE PLAN
SCALE: 1" = 40'

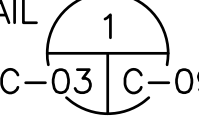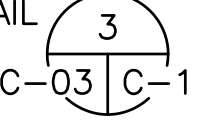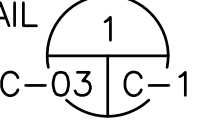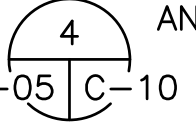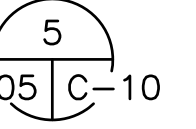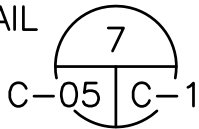- NOTES:**
- FOR TYPE 1 AND 2 FENCE, SEE DETAIL 
 - FOR SINGLE SWING GATE, SEE DETAIL 
 - FOR DOUBLE SWING GATE, SEE DETAIL 
 - PROVIDE "RESTRICTED AREA" SIGN ON OUTER MOST CHAIN LINK FENCE FABRIC EVERY 100 FT, SEE DETAIL  AND 
 - REMOVE AND SALVAGE OTHER EXISTING SIGNS POSTED ON EXISTING FENCES AND GATES. SALVAGED SIGNS TO BE REINSTALLED ON NEW FENCE IN SAME GENERAL LOCATION.
 - PROVIDE "NO PARKING" SIGN ON OUTSIDE FACING GATE FENCE FABRIC, SEE DETAIL 
 - FOR FENCE AND GATE ALIGNMENT, SEE SHEETS C-06 AND C-07 FOR FENCE PLOT PLAN.

  - LEGEND:**
-  TYPE 1 FENCE
 -  TYPE 2 FENCE
 -  TYPE 3 FENCE

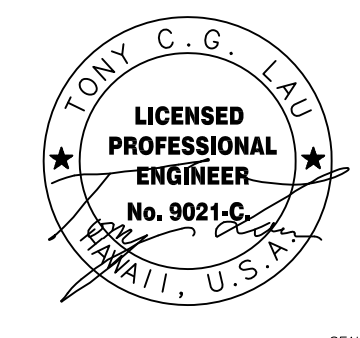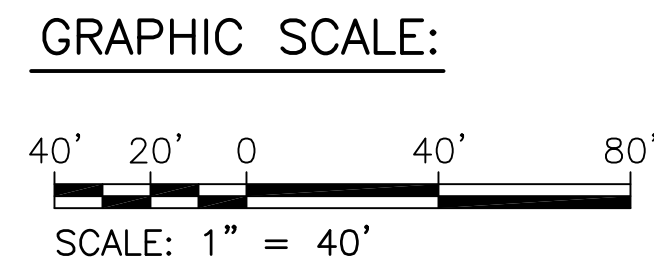



SYMBOL	DATE	APPROVED	DESCRIPTION


SUBMITTAL PHASE				
FINAL				
DES	ET	DRW	BTY	CHK


DEPARTMENT OF DEFENSE DESIGN AND PROJECT MANAGEMENT BRANCH HONOLULU, HAWAII	HAWAII ARMY NATIONAL GUARD PHYSICAL SECURITY AND IMPROVEMENTS FACILITY MANAGEMENT OFFICE HIARNG	WAIAWA PERIMETER FENCE SITE PLAN, SHEET 3
--	--	---

SCALE:	AS NOTED
STATE JOB NO.	CA-1328-D
FEDERAL PROJECT NO.	15140023
SHEET	13 OF 25
C-05	

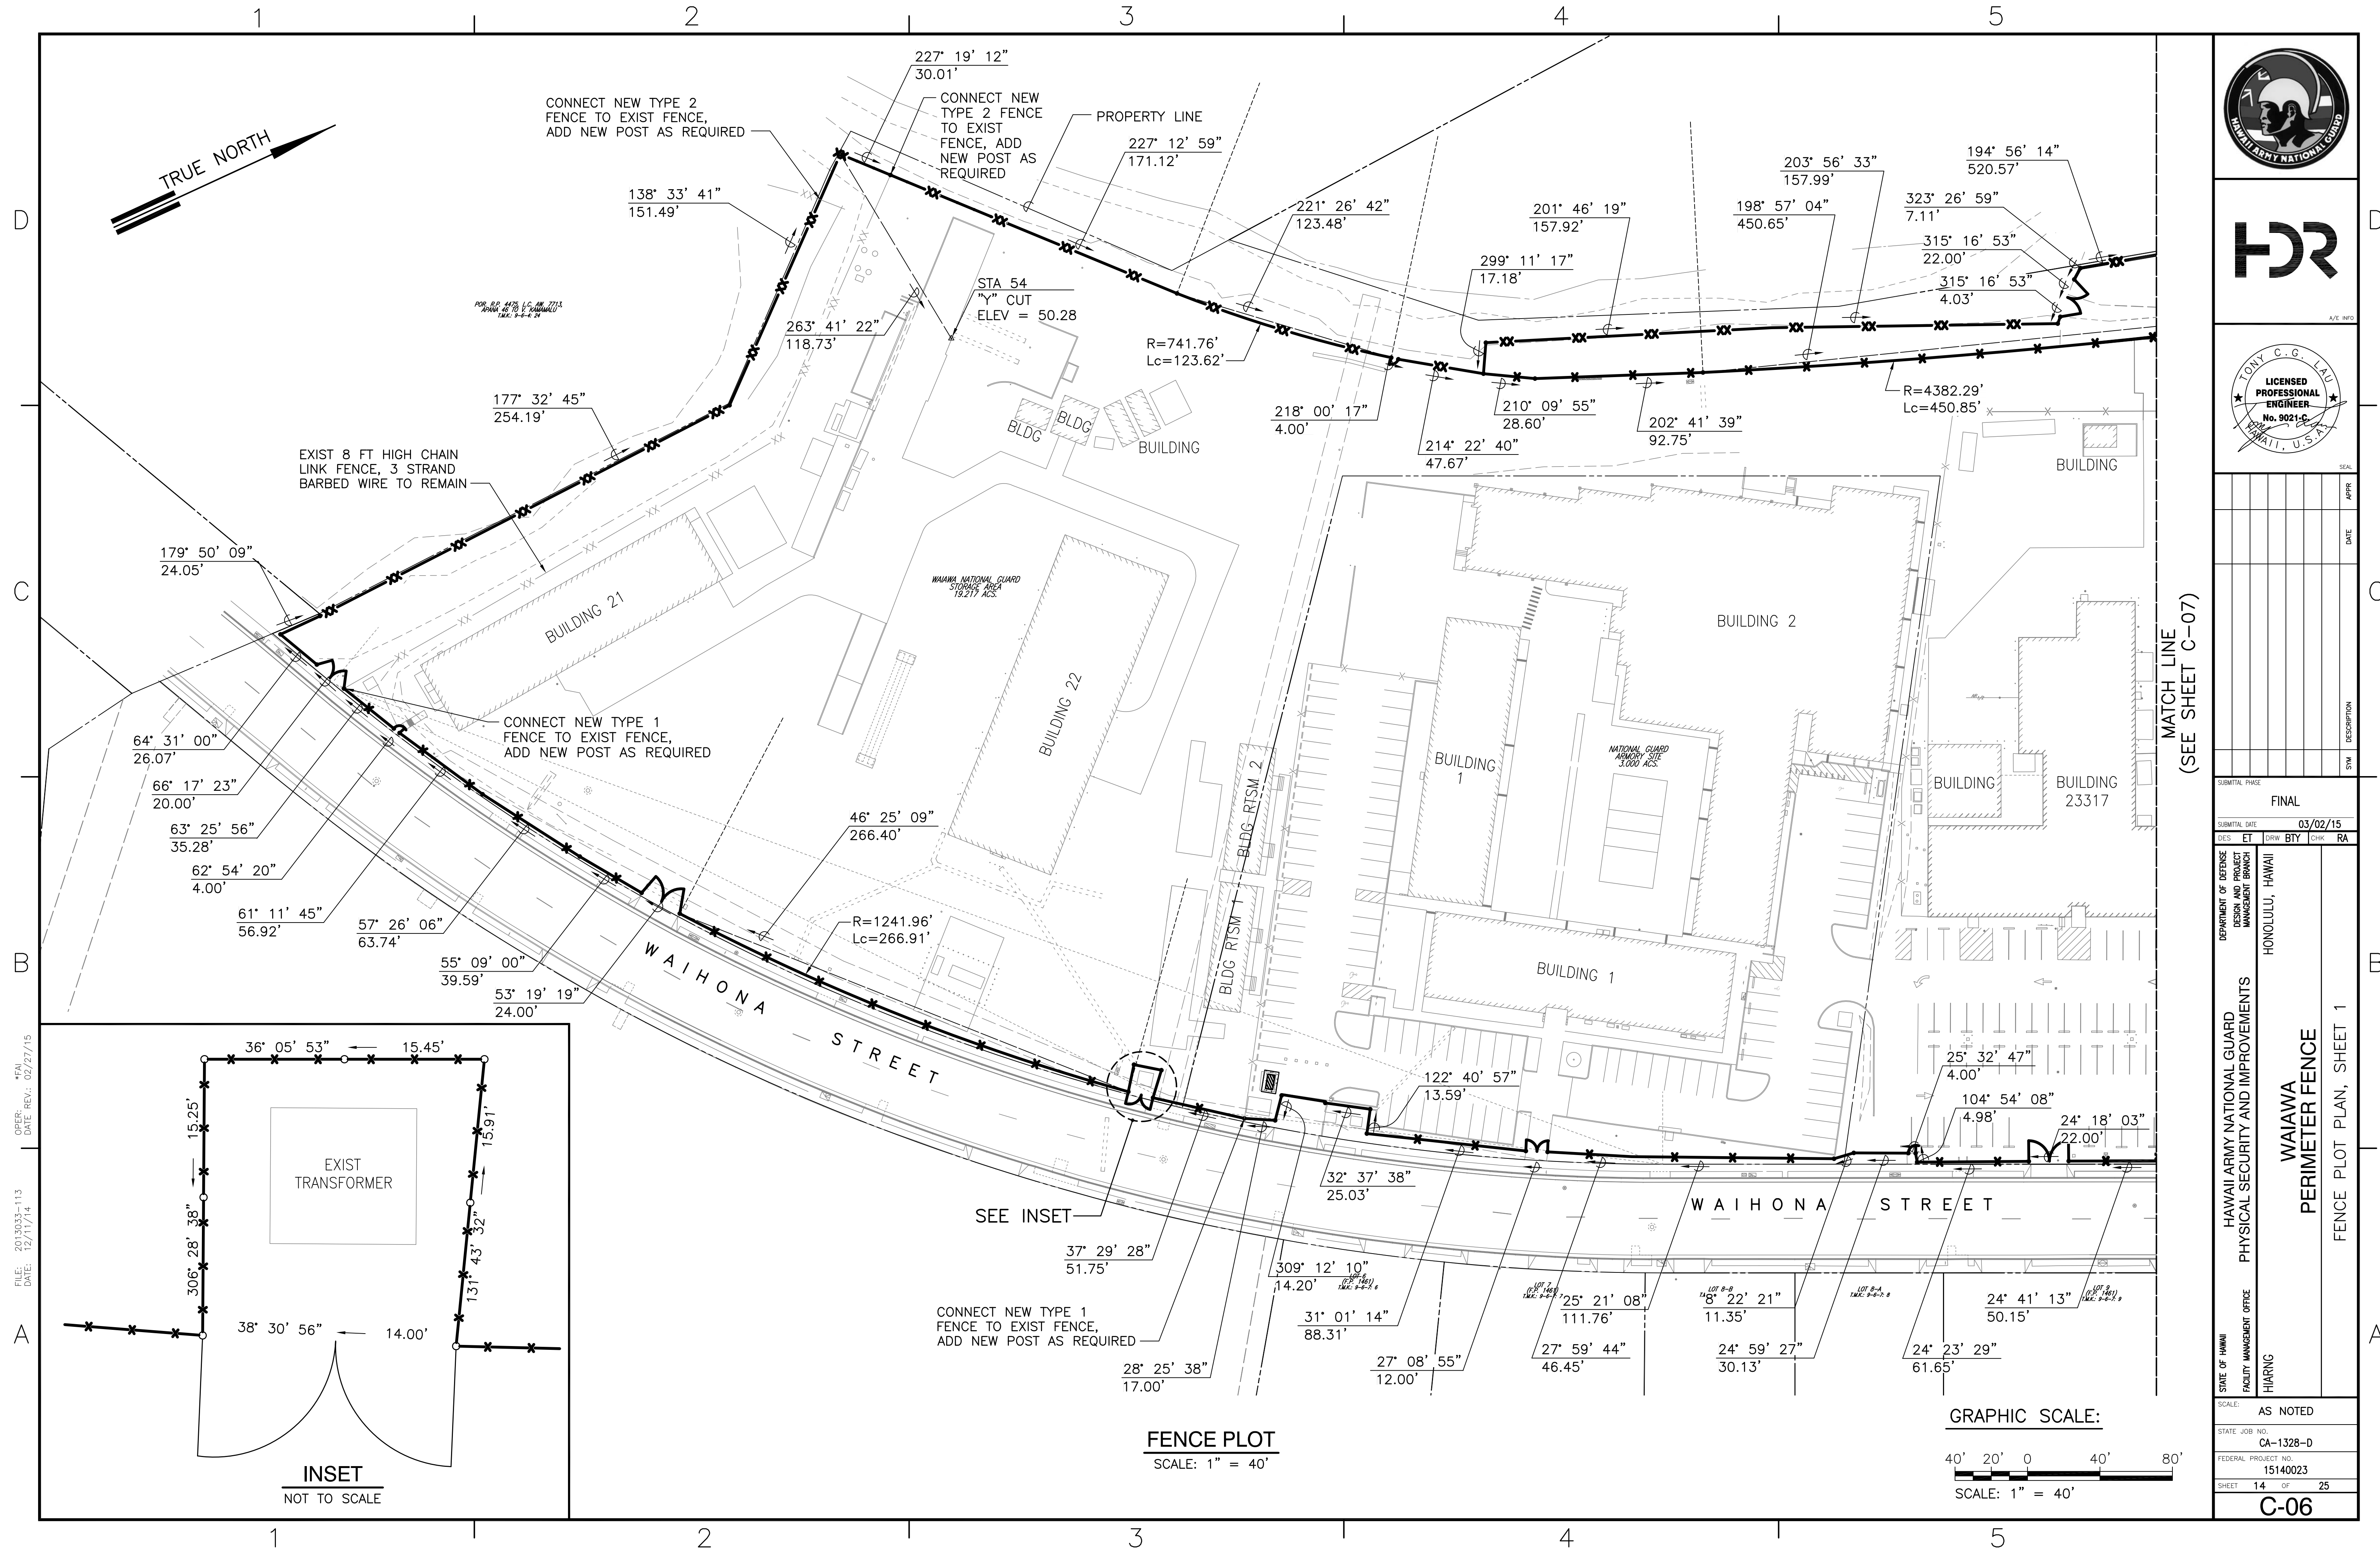

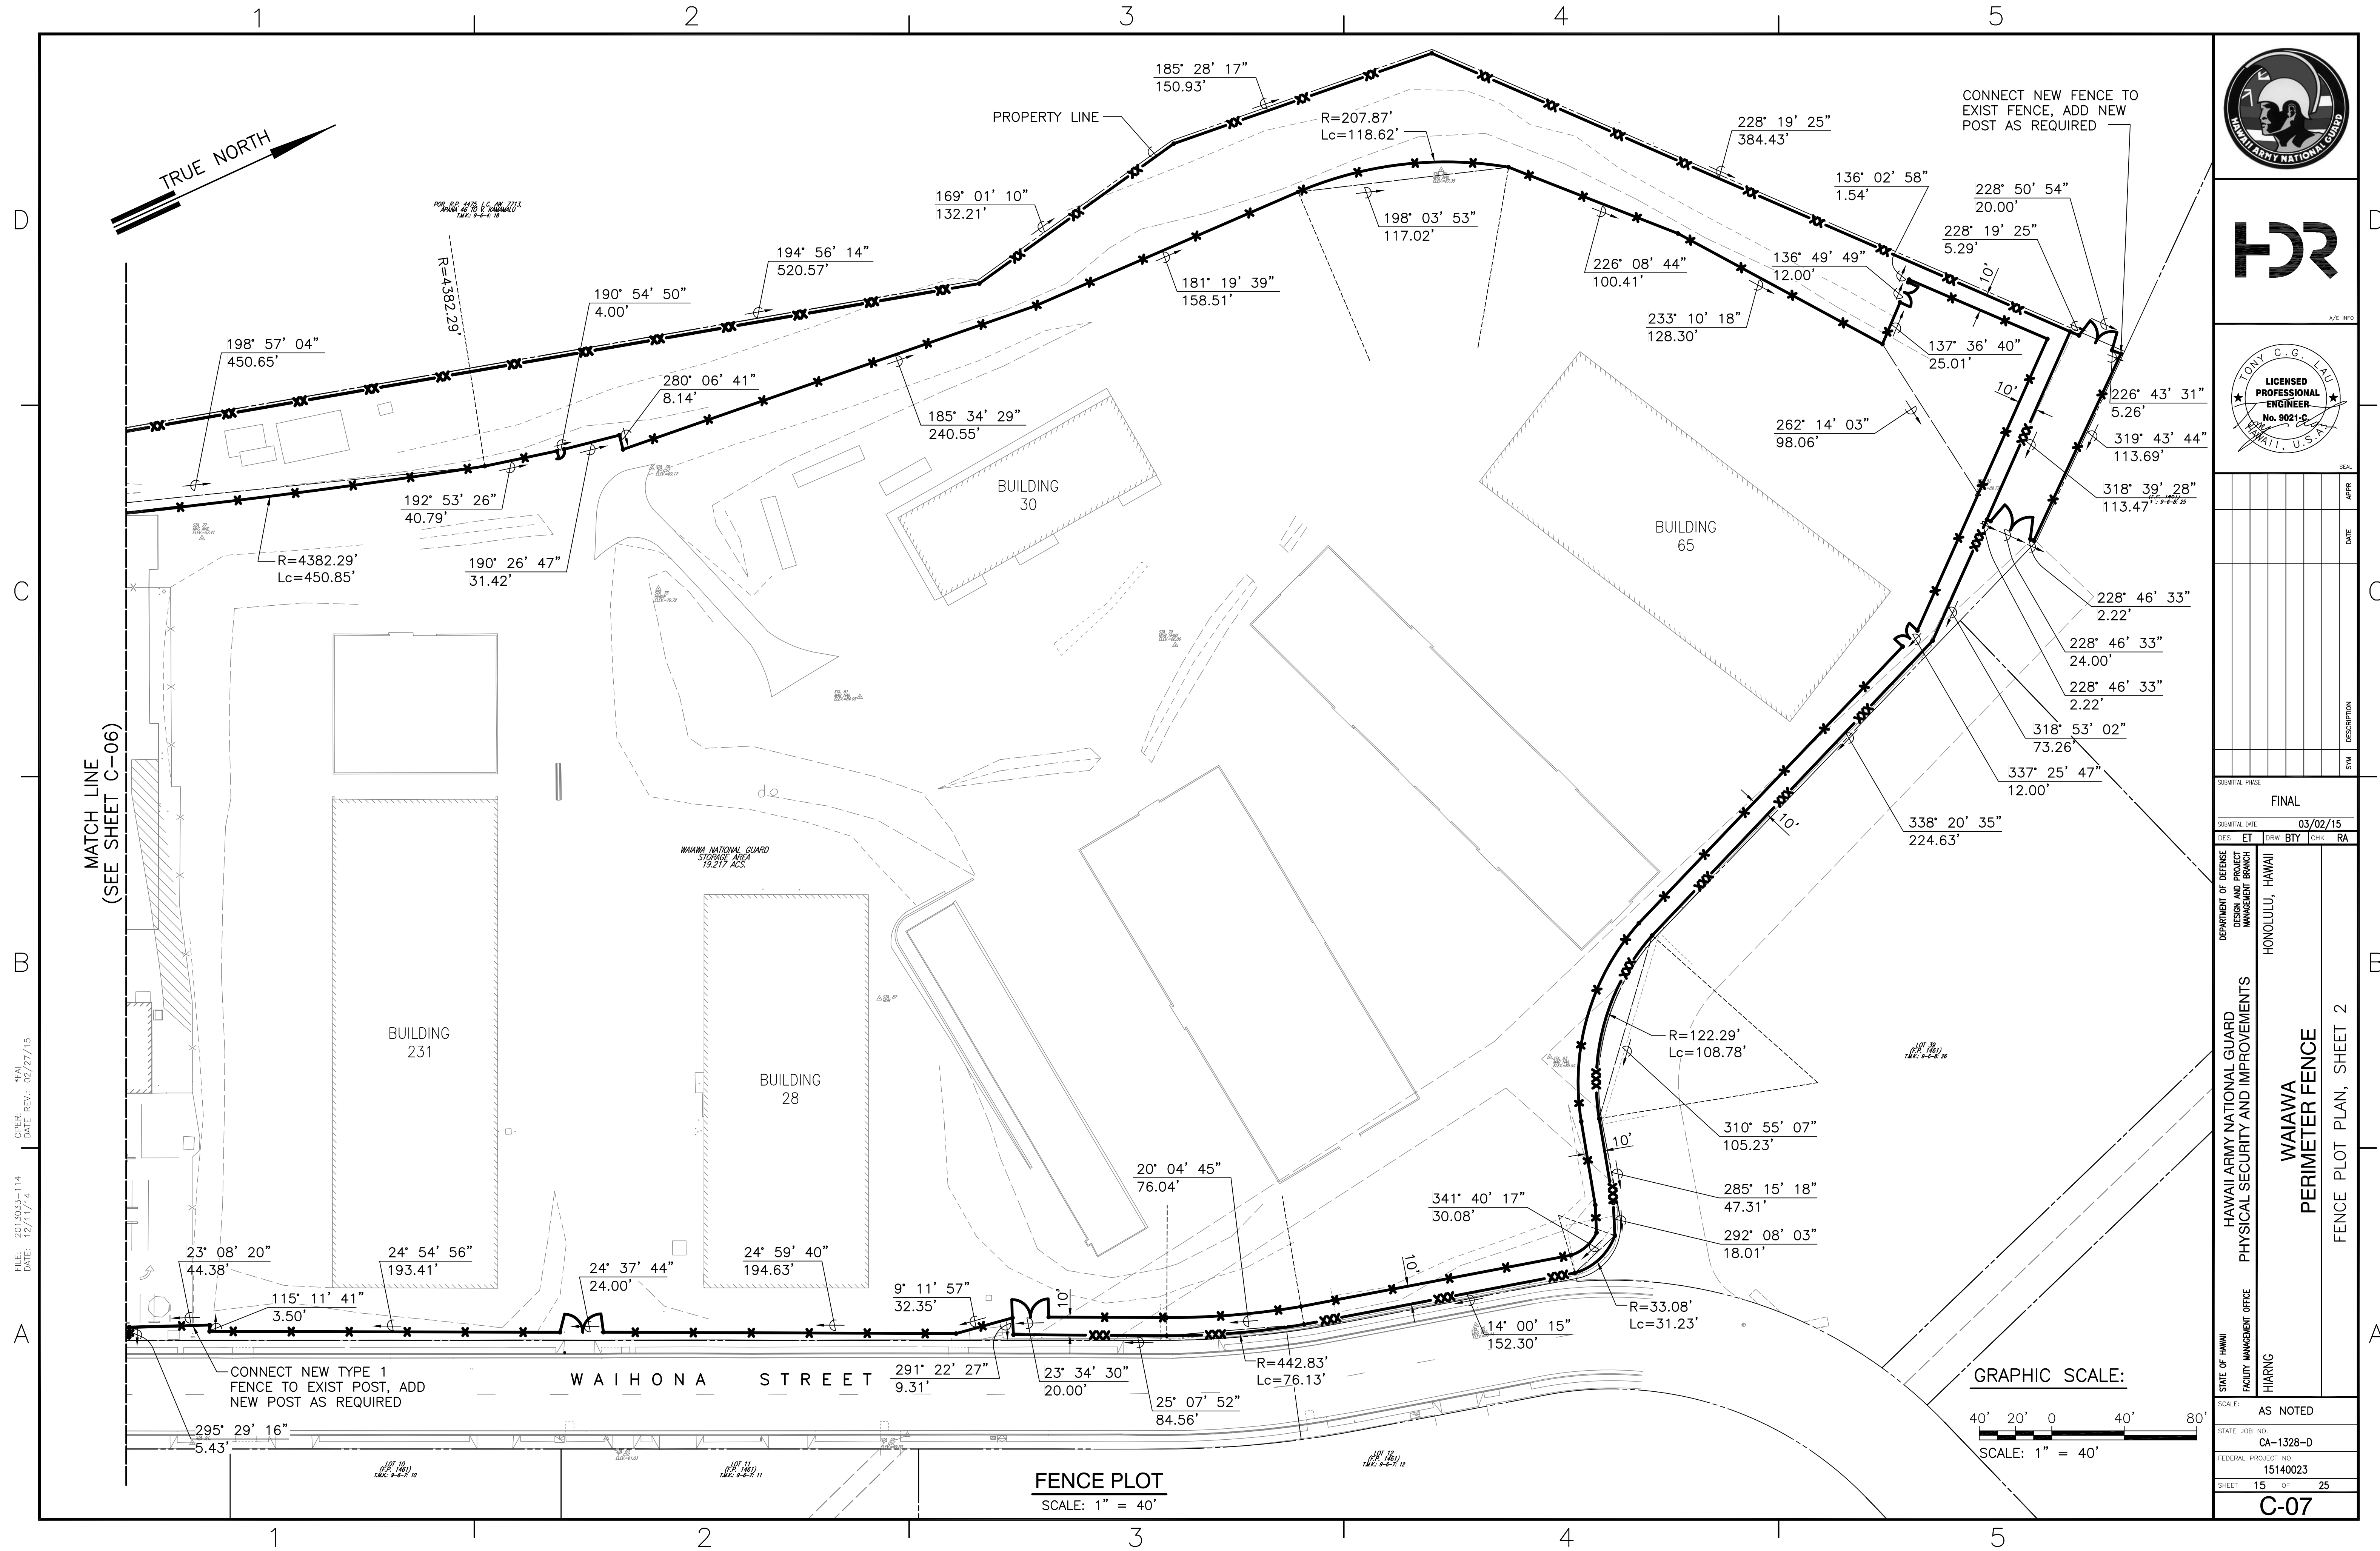

 

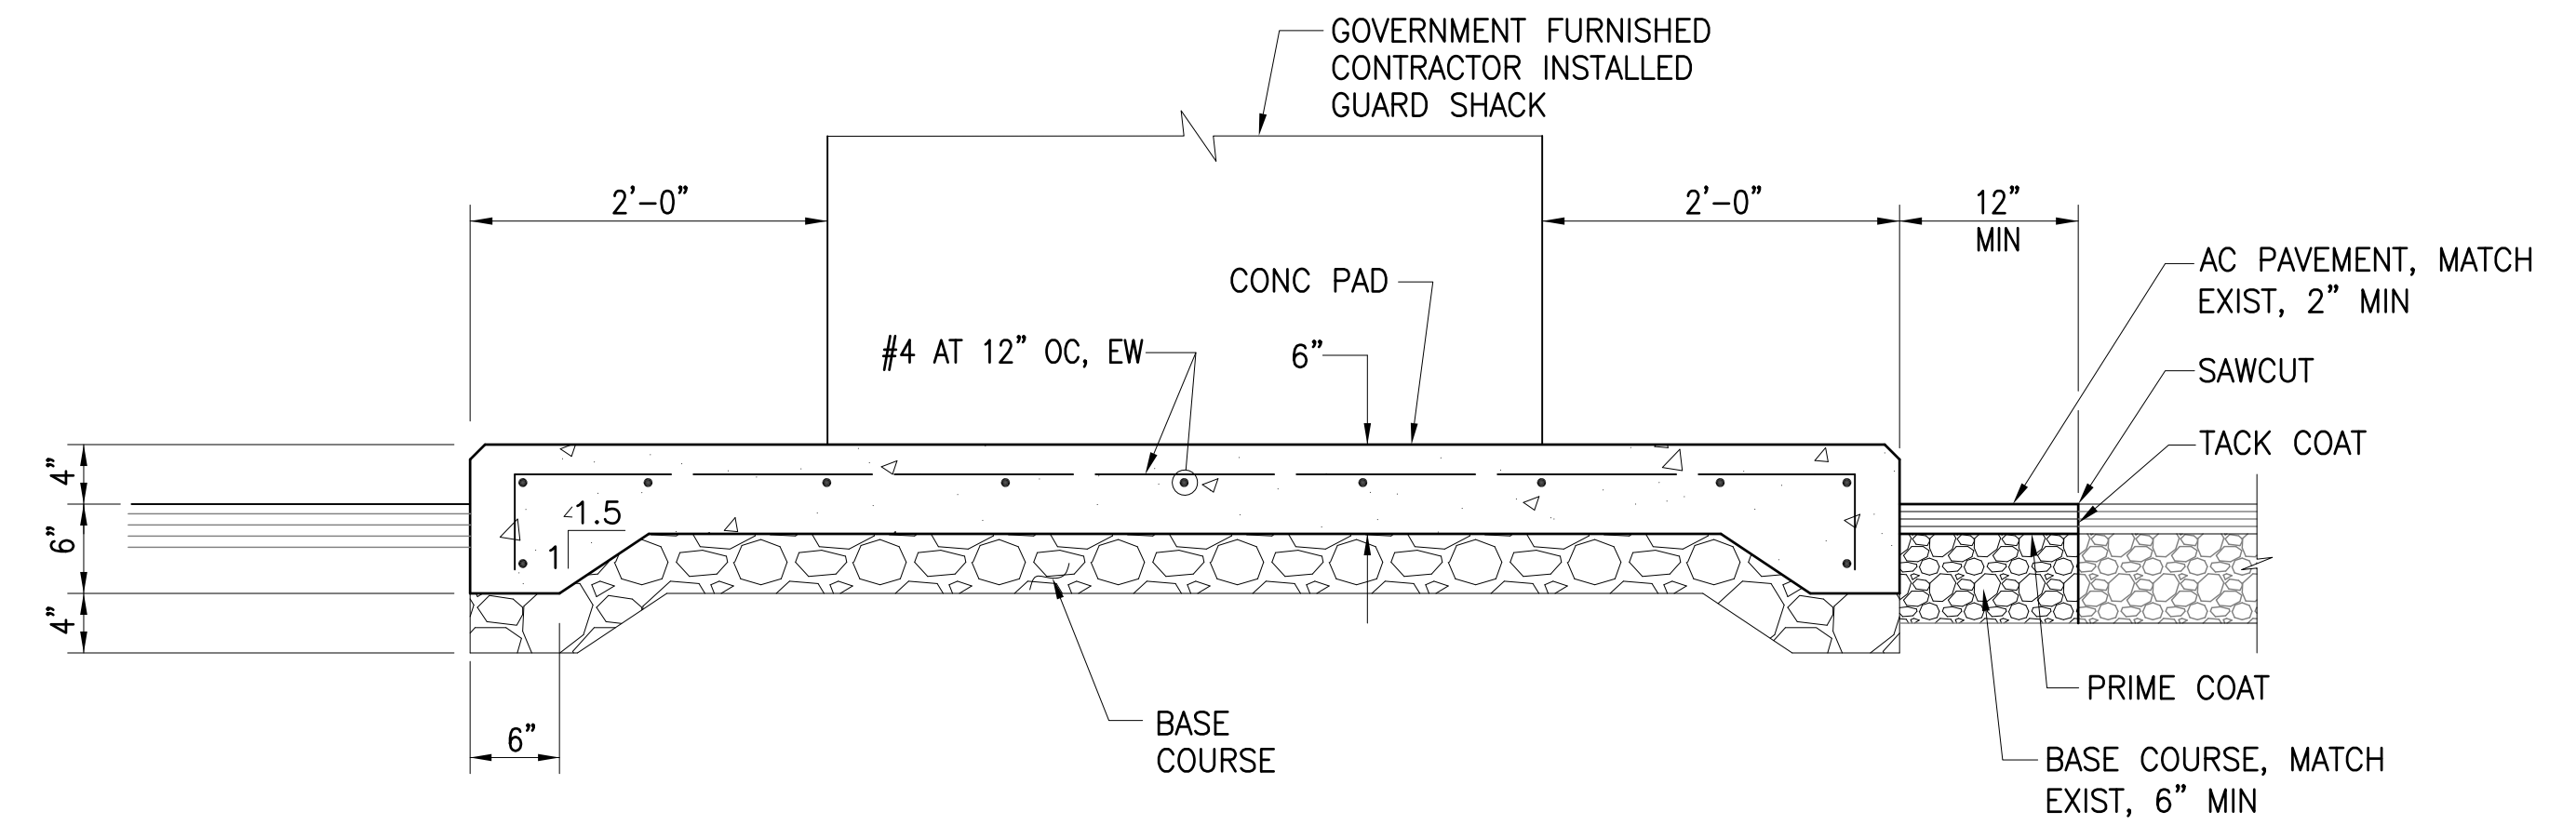

DOUBLE EXTENSION ARM

SCALE: 1" = 1'-0"

C-09 | C-10

2

WARNING
RESTRICTED AREA
KEEP OUT

5'-0" MIN

Technical drawing showing a restricted area with a warning sign and dimensions. The sign reads: WARNING, RESTRICTED AREA, KEEP OUT. The area is marked with a cross-hatch pattern. Dimensions include 5'-0" MIN and 1'-0" MIN. The drawing includes a top section with a grid of 'X' marks and a bottom section with a grid of 'X' marks. The central area is a large rectangle with a cross-hatch pattern. The sign is located in the center of this area. The dimensions are indicated by arrows and text. The 5'-0" MIN dimension is vertical, and the 1'-0" MIN dimension is horizontal. The drawing is a technical representation of a restricted area, likely for a construction or safety plan.

12"

24"

WARNING

RESTRICTED AREA

THIS (INSTALLATION, ACTIVITY, ETC.) HAS BEEN DECLARED A RESTRICTED AREA BY AUTHORITY OF THE COMMANDER IN ACCORDANCE WITH THE PROVISIONS OF THE DIRECTIVE ISSUED BY THE SECRETARY OF DEFENSE, PURSUANT TO THE PROVISIONS OF SECTION 21, INTERNAL SECURITY ACT OF 1950.

UNAUTHORIZED ENTRY IS PROHIBITED

ALL PERSONS AND VEHICLES ENTERING HEREIN ARE LIABLE TO SEARCH. PHOTOGRAPHING OR MAKING NOTES, DRAWINGS, MAPS OR GRAPHIC REPRESENTATIONS OF THIS AREA OR ITS ACTIVITIES ARE PROHIBITED UNLESS SPECIFICALLY AUTHORIZED BY THE COMMANDER. ANY SUCH MATERIAL FOUND IN POSSESSION OF UNAUTHORIZED PERSONS WILL BE CONFISCATED.

(WHITE LETTERING ON RED BACKGROUND)

(RED LETTERING ON WHITE BACKGROUND)

(BLACK LETTERING ON WHITE BACKGROUND)

ENTRY RESTRICTED AREA SIGN

6

VAR C-10

NOT TO SCALE

1. "RESTRICTED AREA" SIGN TO BE POSTED ON OUTER MOST FENCE APPROXIMATELY EVERY 100 FT CENTERED BETWEEN POSTS.
2. "RESTRICTED AREA" SIGN TO BE TO FENCE WITH STANDARD LINK CLIP MOUNTING SYSTEM.
3. "RESTRICTED AREA" SIGN TO BE POSTED ON OUTSIDE FACING FENCE.
4. FOR "RESTRICTED AREA" SIGN, SEE DETAIL 5

Diagram of a "NO PARKING" sign. The sign is rectangular with a red border and the text "NO PARKING" in red. Dimensions are indicated: 18" height and 12" width. Annotations include: (RED BORDER ON WHITE BACKGROUND) and (RED LETTERING ON WHITE BACKGROUND). Below the sign, the text "NO PARKING SIGN" is written, followed by a scale bar labeled "NOT TO SCALE". A circular callout with the number "7" is positioned near the bottom right corner of the sign.

2' 0 2' 4'

SCALE: $\frac{1}{2}" = 1'-0"$

1' 0 1' 2'

SCALE: $1" = 1'-0"$

[illegible]

FINAL				
DATE		03/02/15		
ET	DRW	BTY	CHK	RA

HIARANG PHYSICAL SECURITY AND IMPROVEMENTS WAIAWA PERIMETER FENCE CIVIL DETAILS, SHEET 2	FACILITY MANAGEMENT OFFICE MANAGEMENT BRANCH HONOLULU, HAWAII
---	--


AS NOTED

JOB NO.
CA-1328-D

RAL PROJECT NO.
15140023


18 OF 25

C-10

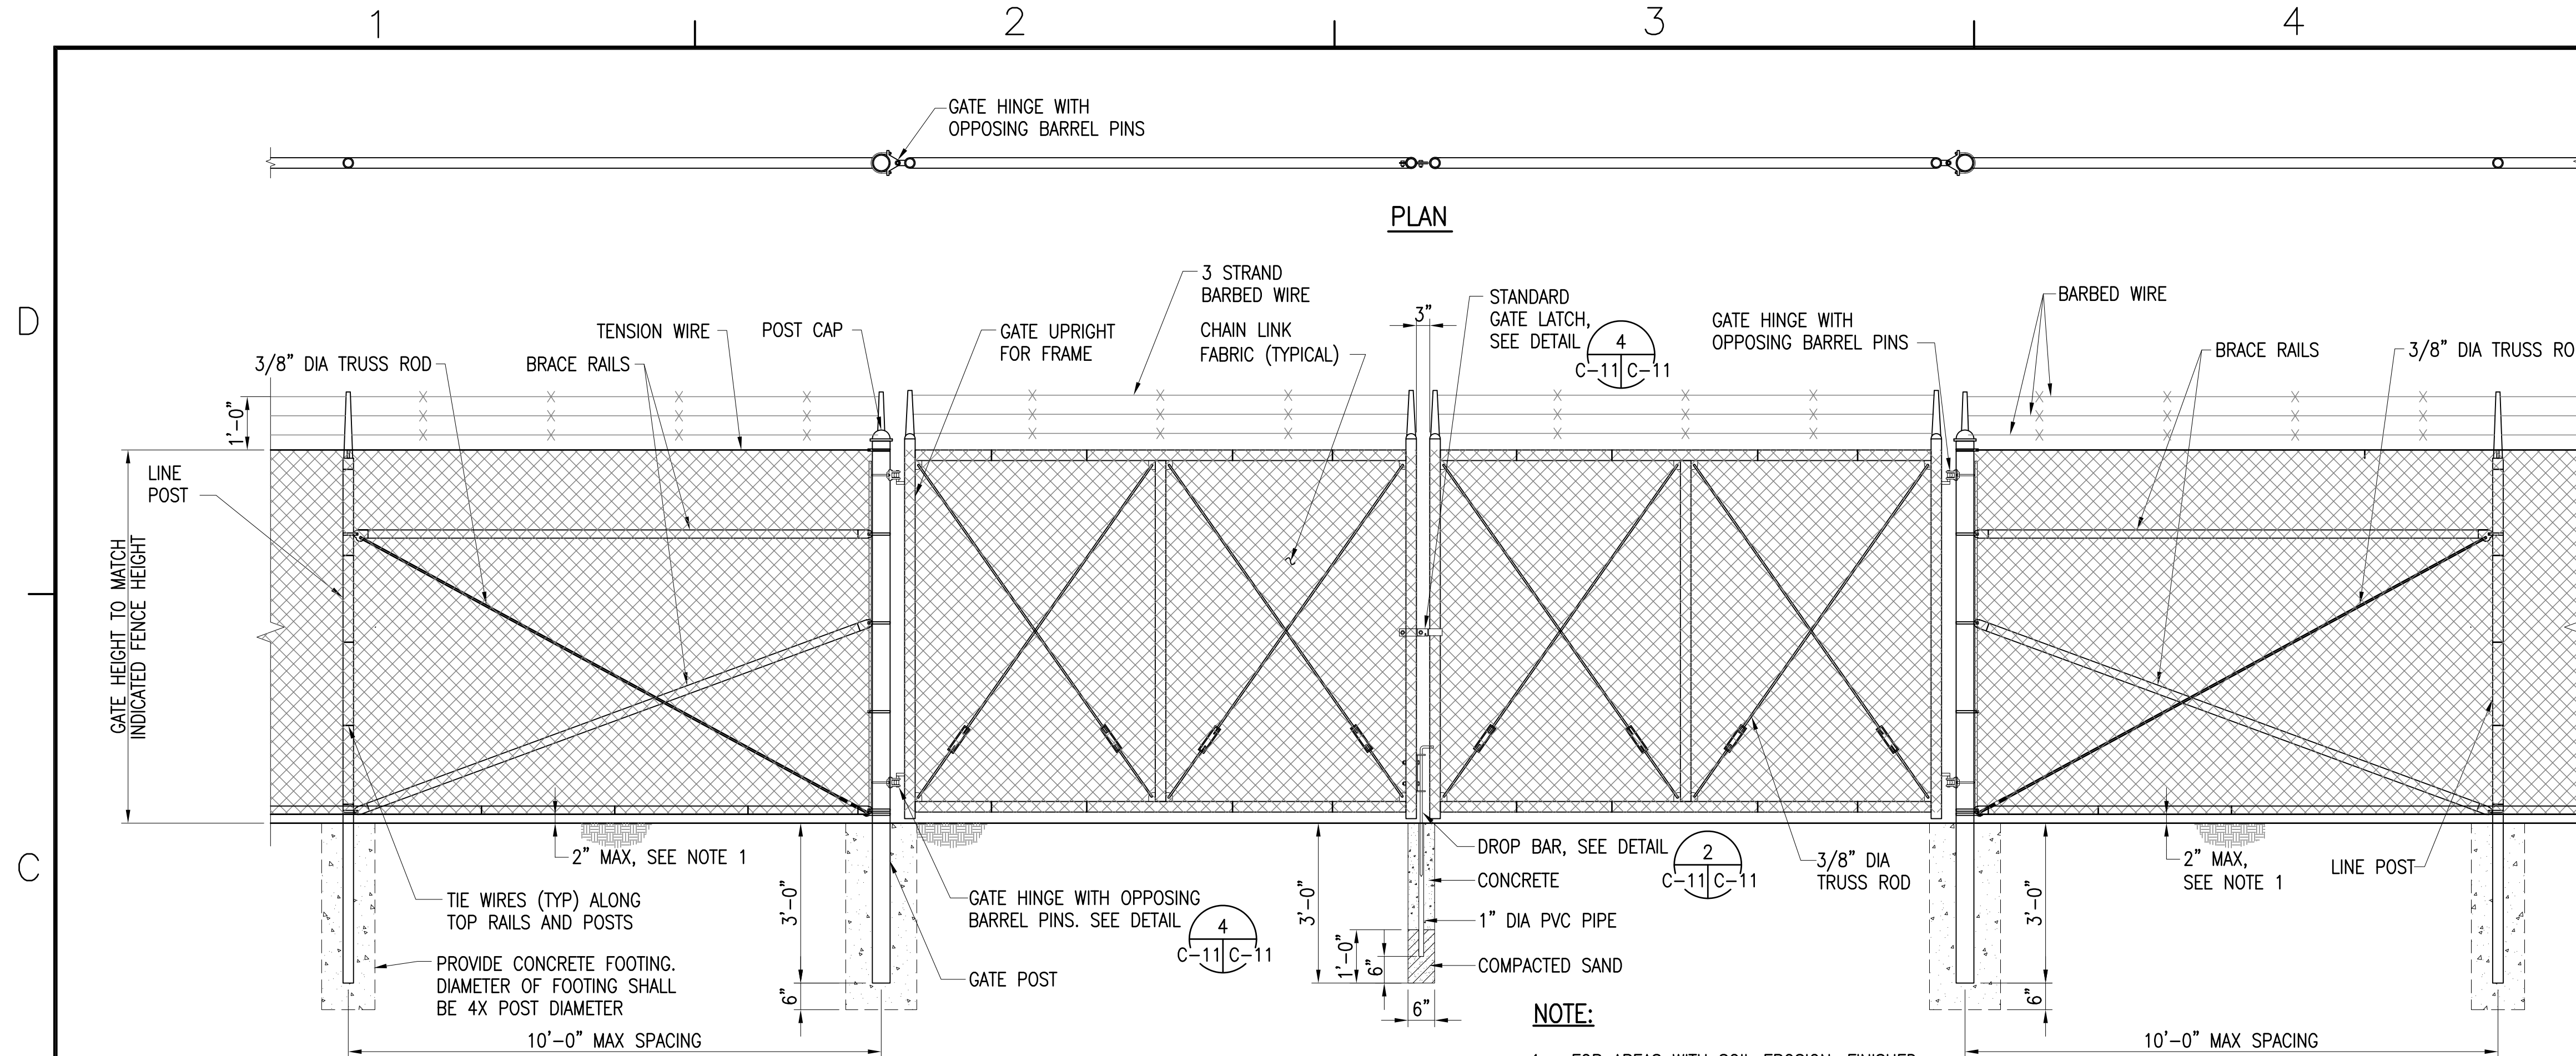


DROP BAR NOTE:

PROVIDE ONE DROP BAR FOR EACH LEAF (TYP). ASSOCIATED GALV SLEEVES TO BE INSTALLED FLUSH WILL GRADE AT FULLY OPEN AND CLOSED POSITIONS. CONTRACTOR SHALL PROVIDE 6" LAYER OF #10 STONE BELOW BOTTOM OF SLEEVE TO ALLOW FOR DRAINAGE.

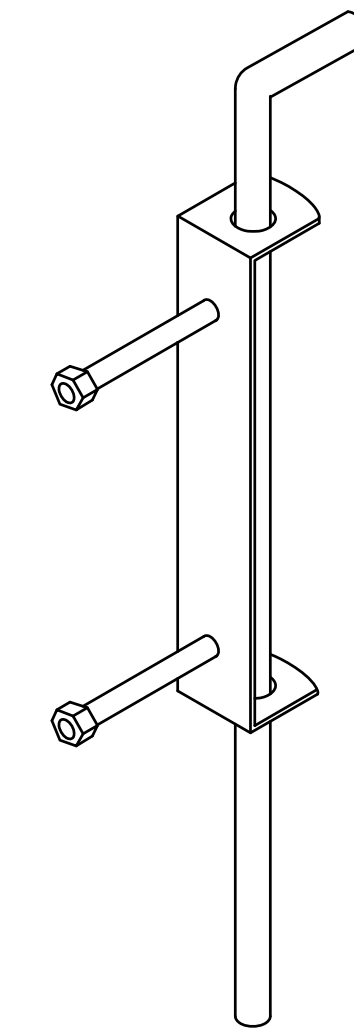

DROP BAR

SCALE: 1" = 1'-0"

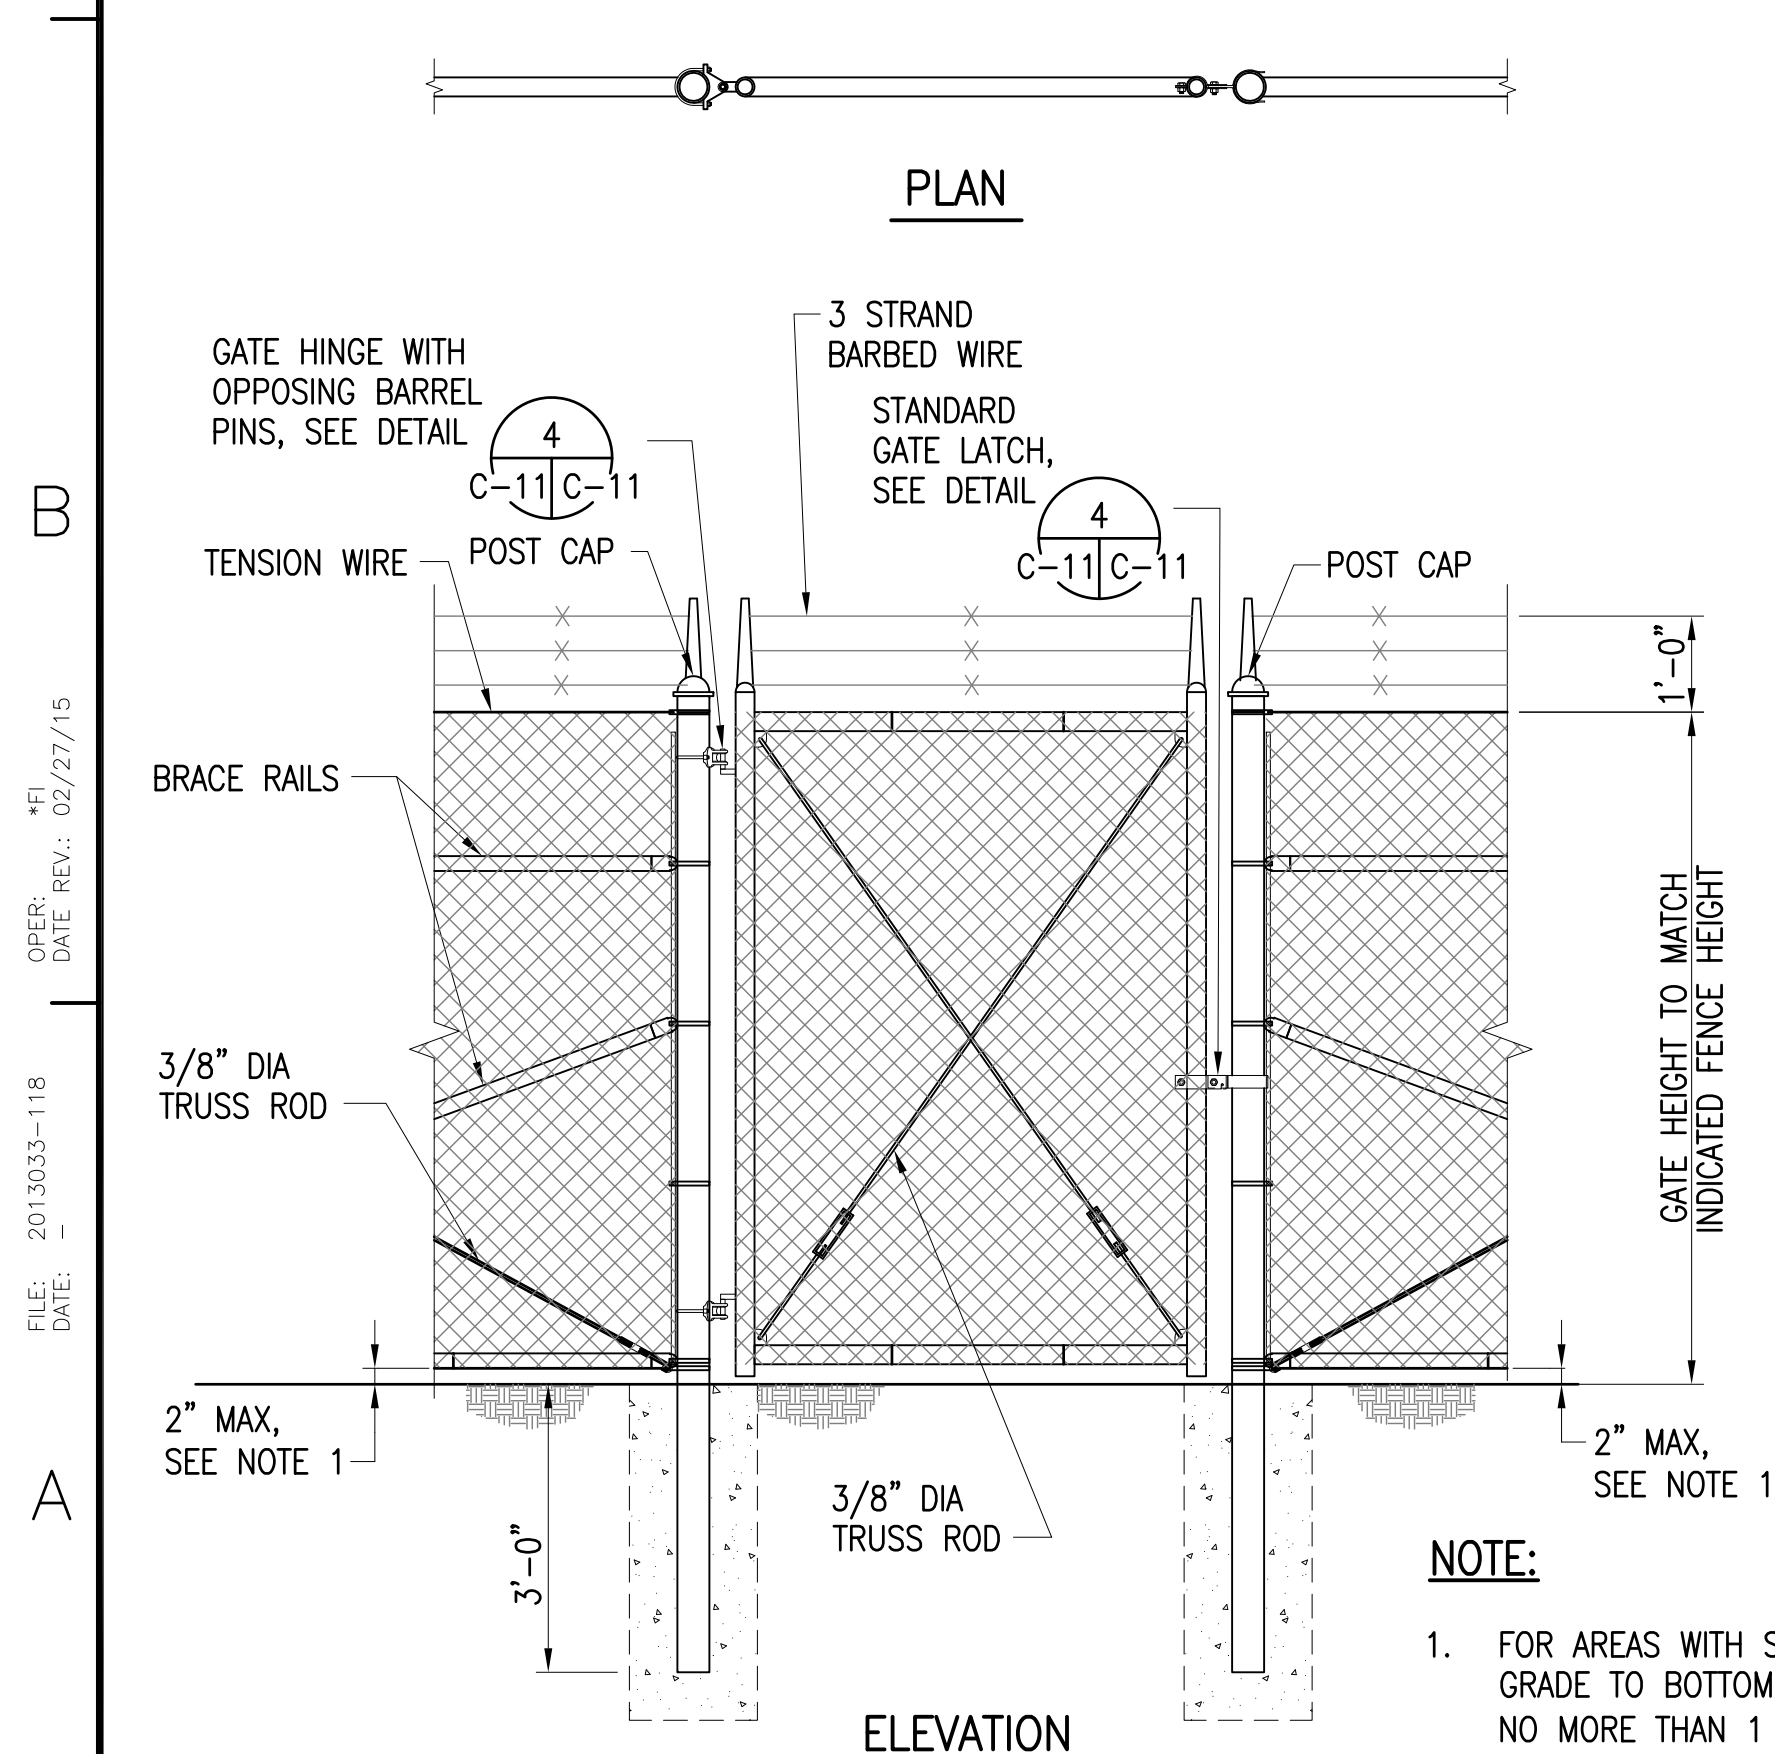

FINAL

SUBMITTAL DATE		03/02/15	
DES	ET	DRW	BTY
		CHK	RA

DEFENSE PROJECT BRANCH	WALL	
------------------------------	------	--

U, HA

DEPARTMENT
DESIGN
MANAGER

HON	D
-----	---

17

RD
EMEN

GUARANTEED TO PROVE
CE

11

ATION
AND
AWA
ER F
S, S

11/11/11
 11/11/11
 11/11/11

ARM
ECUF

W
PRIME

DET

WALL
AL SE

PEP

IVIL

HA SICA		F	C
------------	--	---	---

PHY	
-----	--

ICE

ENT OFF

HAWAII
MANAGEMENT
CSTATE OF
FACILITY
HIARN

SCALE: AS NOTED

STATE JOB NO.
CA-1328-D

FEDERAL PROJECT NO.
15140023

SHEET 19 OF 25

C-11

W:\01_PROJECTS\0101414002-HIARNG_Phy_Sec_L\010102_Waiawa\4002aED1.sgm.dwg, Layout1, 3/3/2015 11:58:24 AM,
Don, 10/1/2005, 1:1

GENERAL NOTES

- THE DRAWINGS DO NOT REFLECT ALL THE EXISTING CONDITIONS THAT MAY BE ENCOUNTERED DURING CONSTRUCTION. VISIT THE PROJECT SITE AND BECOME FAMILIAR WITH THE EXISTING CONDITIONS, THE EXTENT OF ANY DEMOLITION WORK, AND THE NEW WORK PRIOR TO THE START OF ON-SITE CONSTRUCTION ACTIVITIES. REPORT ANY DISCREPANCIES AND/OR DIFFERENCES BETWEEN THE EXISTING CONDITIONS AND THE CONSTRUCTION DOCUMENTS TO THE CONTRACTING OFFICER PRIOR TO COMMENCING CONSTRUCTION. RESOLVE ALL DISCREPANCIES AND QUESTIONS PRIOR TO THE START OF WORK.
- EXISTING DEVICE LOCATIONS, CIRCUIT ASSIGNMENTS, WIRING CONNECTIONS, AND CONDUIT RUNS INDICATED WERE DERIVED FROM AVAILABLE REFERENCE DOCUMENTS AND LIMITED FIELD INVESTIGATION. FIELD VERIFY ALL EXISTING CONDITIONS AND MAKE ANY NECESSARY ADJUSTMENTS TO SATISFY THE INTENT OF THE DRAWINGS AND SPECIFICATIONS.
- RE-ROUTE ALL EXISTING CONDUIT, WIRING AND CABLING TO REMAIN WITHIN THE PROJECT AREA AS NECESSARY TO FACILITATE THE [REMOVAL OF EXISTING EQUIPMENT AS WELL AS THE] INSTALLATION OF ALL NEW EQUIPMENT. REMOVE AND RE-INSTALL ELECTRICAL EQUIPMENT, INCLUDING LIGHTS, TO REMAIN AS REQUIRED.
- VERIFY ALL SYSTEM REQUIREMENTS (ELECTRICAL, MECHANICAL, FIRE ALARM, SPECIALTY SYSTEMS, ETC.) WITH THE SELECTED SYSTEM'S MANUFACTURER OR AUTHORIZED REPRESENTATIVE PRIOR TO COMMENCING WITH ANY WORK. CORRECT ALL DISCREPANCIES SO AS TO PROVIDE A COMPLETE AND OPERATIONAL SYSTEM. RECORD CHANGES ON THE AS-BUILT DRAWINGS.
- CONCEAL ALL CONDUIT WHEREVER REASONABLE; EXPOSED CONDUITS ARE PERMITTED ONLY WHERE SPECIFICALLY SHOWN ON THE DRAWINGS. ALL EXPOSED CONDUITS IN FINISHED AREAS SHALL BE INSTALLED IN THE LEAST VISIBLE LOCATIONS. CARE SHALL BE TAKEN TO INSTALL CONDUIT IN THE MOST AESTHETICALLY PLEASING MANNER.
- PROVIDE NYLON PULLSTRINGS IN ALL EMPTY CONDUITS UNLESS OTHERWISE INDICATED.
- THE TELECOMMUNICATIONS RACEWAY SYSTEM INSTALLATION SHALL COMPLY WITH TIA/EIA-569-C UNLESS OTHERWISE NOTED.
- CONDUIT BODIES (e.g. LB, LR, etc.) SHALL NOT BE PERMITTED IN THE TELECOMMUNICATIONS RACEWAY SYSTEMS UNLESS SPECIFICALLY INDICATED TO BE UTILIZED AND LISTED FOR TELECOMMUNICATIONS SYSTEM USE.
- PROVIDE INSULATED BUSHINGS AT ALL TELECOMMUNICATIONS CONDUIT TERMINATIONS AT ALL BOXES, BACKBOARDS, AND CONDUIT STUBS.
- ALL SURFACE MOUNTED DEVICES SHALL BE INSTALLED UTILIZING FACTORY PAINTED SURFACE MOUNTING ACCESSORIES AND MATCHING DEVICE BOXES FOR THE MOST AESTHETICALLY PLEASING INSTALLATION.
- PAINTING OF ELECTRICAL EQUIPMENT:
A.INTERIOR LOCATIONS - PRIME AND PAINT ALL EXPOSED CONDUITS, BOXES, FITTINGS, SUPPORT CHANNELS, MOUNTING HARDWARE AND ACCESSORIES WITH TWO FINISH COATS TO MATCH THE SURFACE ON WHICH THEY ARE MOUNTED OR TO MATCH THE FINISH OF THE ADJACENT SURFACES. EQUIPMENT SURFACES/COMPONENTS WITH A FACTORY-APPLIED PAINT FINISH NEED NOT BE PAINTED.

B.EXTERIOR LOCATIONS - PRIME ALL EXPOSED CONDUITS, BOXES, FITTINGS, SUPPORT CHANNELS, MOUNTING HARDWARE AND ACCESSORIES WITH A 2-PART EPOXY PRIMER AND FINISH WITH 2 COATS OF AN ALIPHATIC ACRYLIC URETHANE PAINT. PAINT FINISH TO MATCH THE SURFACE ON WHICH THEY ARE MOUNTED OR TO MATCH THE FINISH OF THE ADJACENT SURFACES. STAINLESS STEEL MATERIALS NEED NOT BE PAINTED.
- INSTALLATION OF NEW DEVICES AND CONDUITS SHALL NOT INTERFERE WITH THE OPENING OF DOORS AND/OR WINDOWS. ACCESS AND/OR VISIBILITY OF DEVICES SHALL NOT BE BLOCKED BY DOORS IN THE OPEN POSITION.
- PENETRATIONS THROUGH FIRE-RATED WALLS AND FLOORS SHALL BE SEALED TO MAINTAIN FIRE RATINGS. UTILIZE 3M CP25, PUTTY 303 OR EQUIVALENT.
- SHOULD PROJECT CONDITIONS REQUIRE DEVIATIONS FROM THE CONSTRUCTION DRAWINGS, MARK SUCH CHANGES ON THE AS-BUILT DRAWINGS. IF THESE CHANGES REQUIRE ALTERNATE METHODS TO THOSE SPECIFIED IN THE CONTRACT DOCUMENTS, SUBMIT DRAWINGS SHOWING THE PROPOSED ALTERNATE METHODS TO THE CONTRACTING OFFICER FOR REVIEW AND APPROVAL. DO NOT PROCEED UNTIL APPROVAL IS OBTAINED FROM THE [CONTRACTING OFFICER.

HANDHOLE SCHEDULE

- 21 13" x 24" ELECTRIC HANDHOLE
- 62 17" x 30" TELECOMMUNICATIONS HANDHOLE

ELECTRICAL SYMBOLS


⌒	BARRED LETTER IN OR ADJACENT TO LTG FIXTURE SYMBOL INDICATES FIXTURE TYPE
⌒	PANELBOARD, 6'-6" TO TOP
⌒	TELECOMM BACKBOARD, 4'W x 8'H x 3/4" THK TERMITE TREATED PLYWOOD, PAINT WITH TWO COATS WHITE FIRE-RETARDANT PAINT
⌒	TELECOMM CABINET, 6'-6" TO TOP
⌒	DUPLEX RECEPTACLE w/ GFCI PROTECTION, NEMA 5-20R, 125V, +18" AFF UON
⌒	LARGE JUNCTION BOX, SIZE AS INDICATED
⌒	LARGE JUNCTION BOX, WALL MOUNTED, SIZE AS INDICATED
⌒	SMALL JUNCTION (OUTLET) BOX
⌒	SMALL JUNCTION (OUTLET) BOX, WALL MOUNTED
⌒	DISCONNECT SWITCH, HEAVY DUTY, HP-RATED, SIZE AS INDICATED, +5'-6" TO TOP UON
⌒	EQUIPMENT CONNECTION
⌒	TELECOMMUNICATION SYSTEM OUTLET BOX, 4-11/16"SQ. x 2-1/8"D w/ SINGLE GANG PLASTER RING, BLANK DEVICE PLATE COVER, +18"AFF UON
\$	SINGLE POLE SWITCH, 20A, 120/277V - 3=3 WAY, 4=4 WAY, D=DIMMER, FD=FLUOR DIMMER, M=MANUAL MOTOR SWITCH, P=PILOT, F=FAN CONTROLLER, K=KEY OPERATED, +48" AFF
WP	WEATHERPROOF
CO	CONDUIT ONLY
NL	NIGHT LIGHT
CT	MOUNTED 6" ABOVE COUNTERTOP BACKSPLASH
UON	UNLESS OTHERWISE NOTED

—○	CONDUIT UP
—→	CONDUIT DOWN
—	CONDUIT & WIRING IN WALL OR CEILING
- - -	CONDUIT & WIRING BELOW REFERENCED PLANE
- - - -	CONDUIT & WIRING EXPOSED
—→	HOMERUN TO APPLICABLE PANEL
—┘	CONDUIT STUB
~~~~~	FLEXIBLE CONDUIT
—C—	TELECOMMUNICATION SYSTEM CONDUIT, 1"C MIN w/ PULLSTRING UON

SHADED AREA DESIGNATES THE REQUIRED WORKING SPACE CLEARANCE PER NEC 110-16. COORDINATE CLEARANCE WITH ALL OTHER TRADES. ENSURE THAT NO OTHER EQUIPMENT, STRUCTURE, OR PERMANENT APPURTENANCE ENCROACHES INTO THIS ZONE.

MINIMUM CONDUIT SIZE SHALL BE 3/4". ANY CIRCUIT W/ NO FURTHER DESIGNATION INDICATES A TWO (2) WIRE CIRCUIT. CIRCUITS W/ ADDITIONAL WIRES ARE INDICATED AS FOLLOWS: --- 3 WIRES, ---- 4 WIRES, ETC. MINIMUM CONDUCTOR SIZE SHALL BE #12. ALTHOUGH NOT INDICATED A SEPARATE GREEN GROUND CONDUCTOR SIZED PER THE N.E.C. SHALL BE INSTALLED IN ALL BRANCH CIRCUIT CONDUITS.

## DUCT DESIGNATION

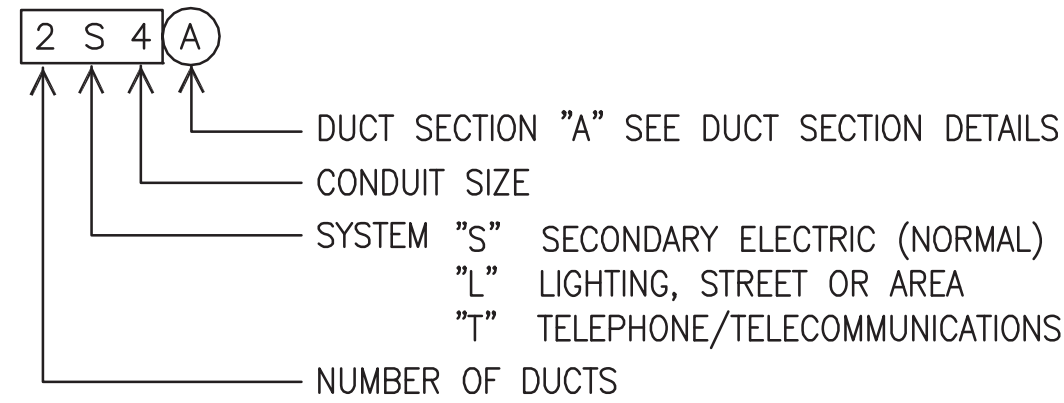


14002





A/E INFO

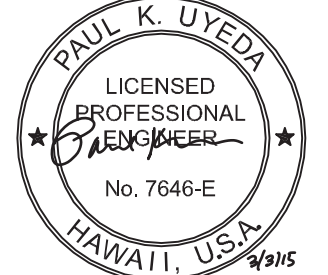

PAUL K. UYEDA  
LICENSED PROFESSIONAL ENGINEER  
No. 7646-E  
HAWAII, U.S.A.  
MK ENGINEERS, LTD.  
LICENSE EXPIRATION DATE: 4/30/16

										SEAL
										APPR
										DATE
										DESCRIPTION
										SYM

SUBMITAL PHASE

FINAL

DES	PKU	DRW	MKE	CHK	PKU
-----	-----	-----	-----	-----	-----

DEPARTMENT OF DEFENSE  
DESIGN AND PROJECT  
MANAGEMENT BRANCH  
HONOLULU, HAWAII

HAWAII ARMY NATIONAL GUARD  
PHYSICAL SECURITY AND IMPROVEMENTS

WAIAWA  
PERIMETER FENCE

STATE OF HAWAII  
FACILITY MANAGEMENT OFFICE  
HIARNG

ELECTRICAL SYMBOLS AND NOTES

SCALE: AS NOTED

STATE JOB NO. CA-1328-0

FEDERAL PROJECT NO. 15140023

SHEET 21 OF 25

E-01







# SITE ELECTRICAL PLAN

 SCALE: 3/32" = 1'-0"

## NOTES:

1. ——— LIGHT LINES DENOTE EXISTING CONDITION  
——— BOLD LINES DENOTE NEW WORK
- 2 SAWCUT AND PATCH TO MATCH PATCHWORK WITH THAT OF EXISTING SIDEWALK.
- 3 SURFACE MOUNT CONDUIT TO EXTERIOR WALL. ROUTE BELOW GROUND TO HANDHOLE.

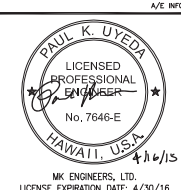


DATE	DESCRIPTION
4/17/15	ADDENDUM 1

FINAL
SUBMITTAL DATE: 03/02/15
DES: PKU DRW: MKE CHK: PKU

DEPARTMENT OF DEFENSE DESIGN AND PROJECT MANAGEMENT BRANCH HONOLULU, HAWAII	HAWAII ARMY NATIONAL GUARD PHYSICAL SECURITY AND IMPROVEMENTS FACILITY MANAGEMENT OFFICE HIAIRNG	WAIKAWA PERIMETER FENCE SITE ELECTRICAL PLAN
--------------------------------------------------------------------------------------	-----------------------------------------------------------------------------------------------------------	----------------------------------------------------




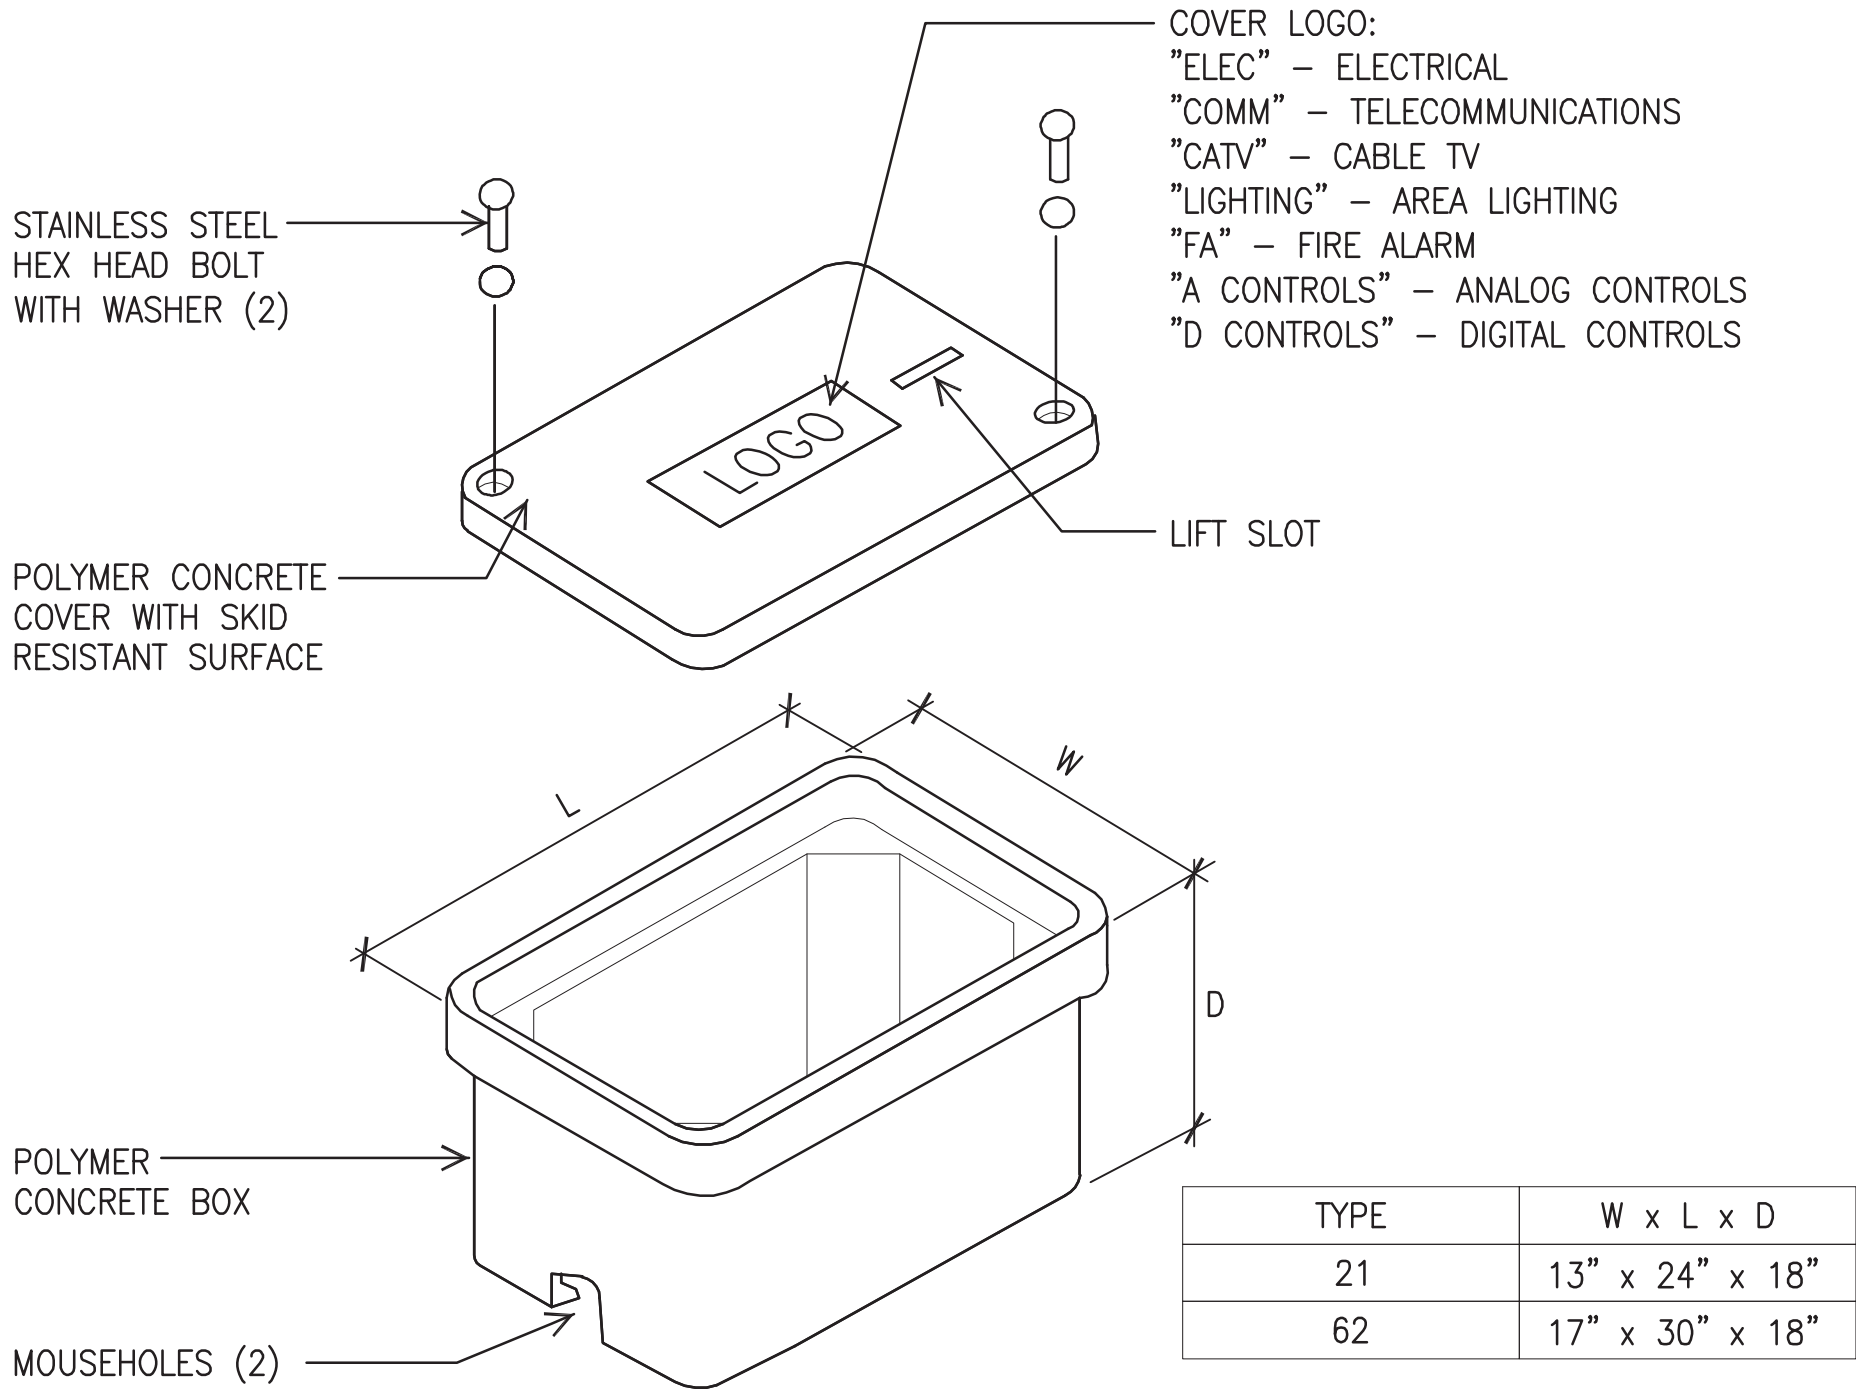

**A** **SMALL POLYMER CONCRETE PULLBOX DETAIL**  
E-03 NOT TO SCALE

NOTES:

- PULLBOX ASSEMBLY SHALL HAVE A 10,400 LB. DESIGN LOAD (8,000 LB. WHEEL LOAD TIMES 1.3 IMPACT FACTOR) RATING IN ACCORDANCE WITH ASTM C857 A-8 VEHICLE AND PEDESTRIAN LOADING.
- BOX AND BASE SHALL NOT CONTAIN STEEL REINFORCING.
- PULLBOX SHALL BE SET ON COMPACTED GRANULAR FILL. PROVIDE BUILD-UP BRICKS WITH MORTAR AS NECESSARY TO ACCOMMODATE DUCTLINE ENTRIES.
- PROVIDE CONCRETE COLLAR RING SURROUNDING PULLBOX, SEE **B** E-03.
- BOXES SHALL BE MANUFACTURED BY ARMORCAST OR EQUIVALENT. EQUIVALENT MUST BE SUBMITTED FOR APPROVAL PRIOR TO BIDDING.

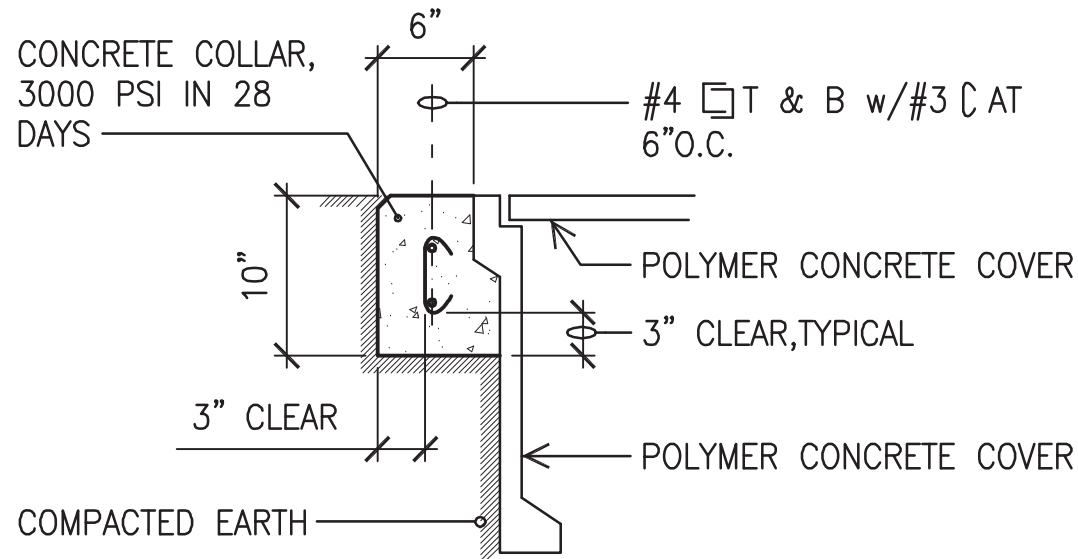


**B** **CONCRETE COLLAR RING**  
E-03 NOT TO SCALE



**HR**

A/E INFO

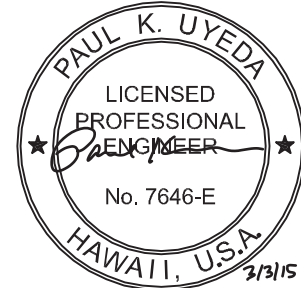

MK ENGINEERS, LTD.  
LICENSE EXPIRATION DATE: 4/30/16

SYN	DESCRIPTION	DATE	APPR

SUBMITTAL PHASE			
FINAL			
SUBMITTAL DATE: 03/02/15			
DES	PKU	DRW	MKE
CHK	PKU		


STATE OF HAWAII	HAWAII ARMY NATIONAL GUARD	DEPARTMENT OF DEFENSE
FACILITY MANAGEMENT OFFICE	PHYSICAL SECURITY AND IMPROVEMENTS	DESIGN AND PROJECT MANAGEMENT BRANCH
HIAENG	HONOLULU, HAWAII	
WAIAWA PERIMETER FENCE		
PULLBOX DETAILS		

SCALE:	AS NOTED
STATE JOB NO.	CA-1328-D
FEDERAL PROJECT NO.	15140023
SHEET	23 OF 25

**E-03**




A  
B  
C  
D

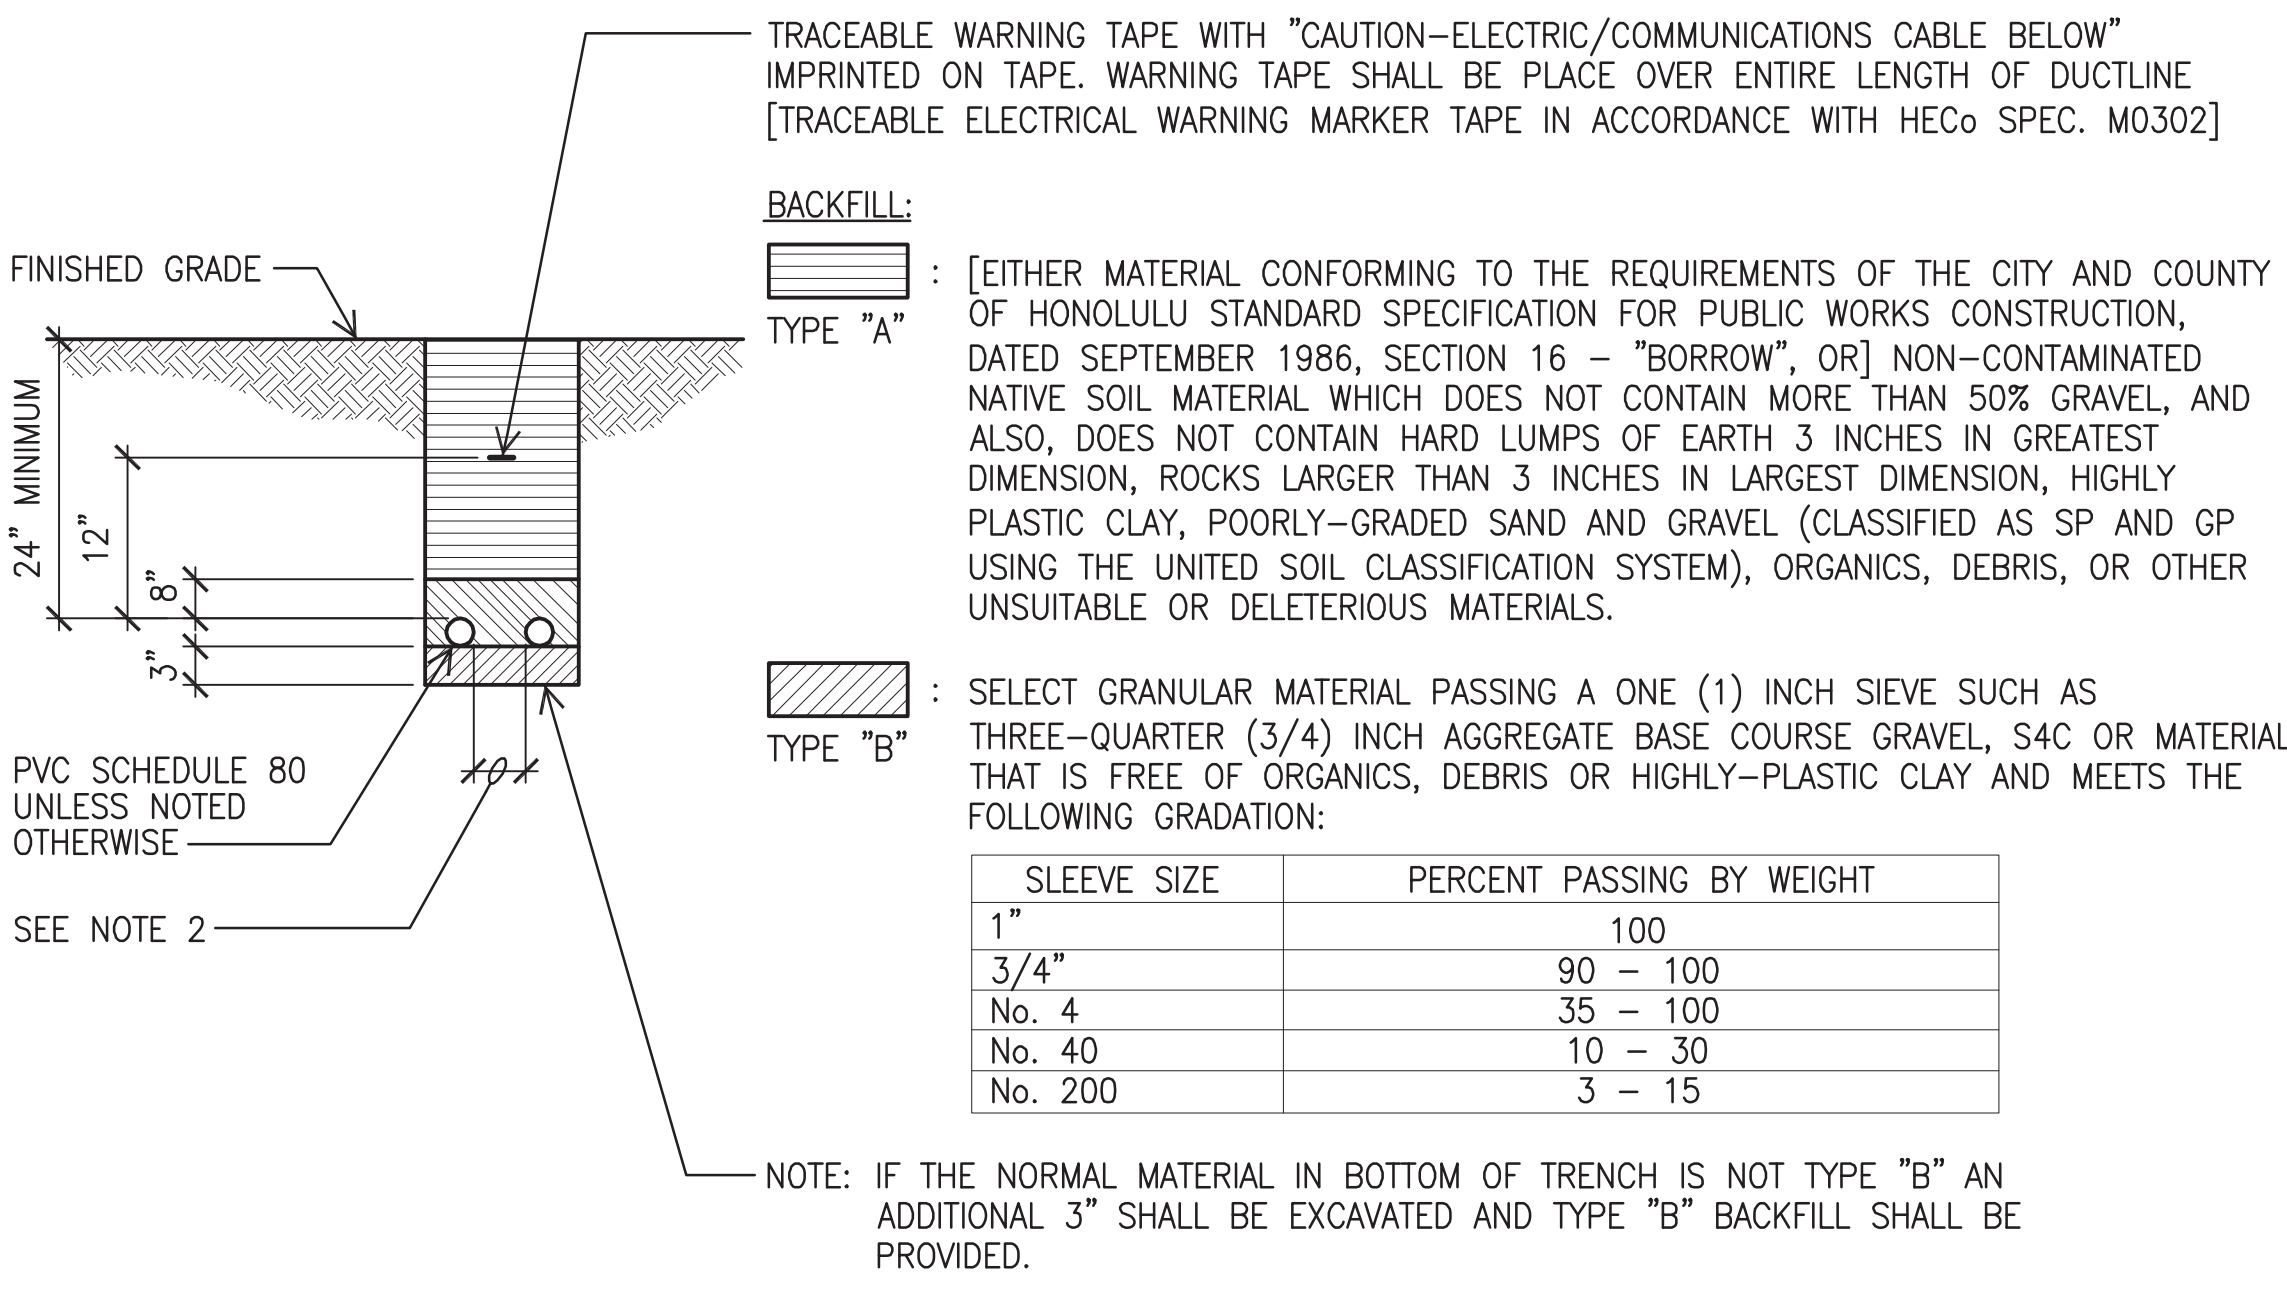


**A** TYPICAL DUCT SECTION (DIRECT BURIED)

- E-04 NOT TO SCALE
- NOTES:
- WHERE TRENCH ENCOUNTERS EXISTING CONCRETE OR ASPHALT CONCRETE, SURFACE SHALL BE SAWCUT. BACKFILL, COMPACT AND PATCH SURFACE TO MATCH ADJACENT AREA. SEE TRENCH RESTORATION DETAIL.
  - PROVIDE 3" SEPARATION BETWEEN DUCTS OF SAME SYSTEM AND 12" SEPARATION BETWEEN ELECTRICAL DUCTS AND DUCTS OF DIFFERENT SYSTEMS.

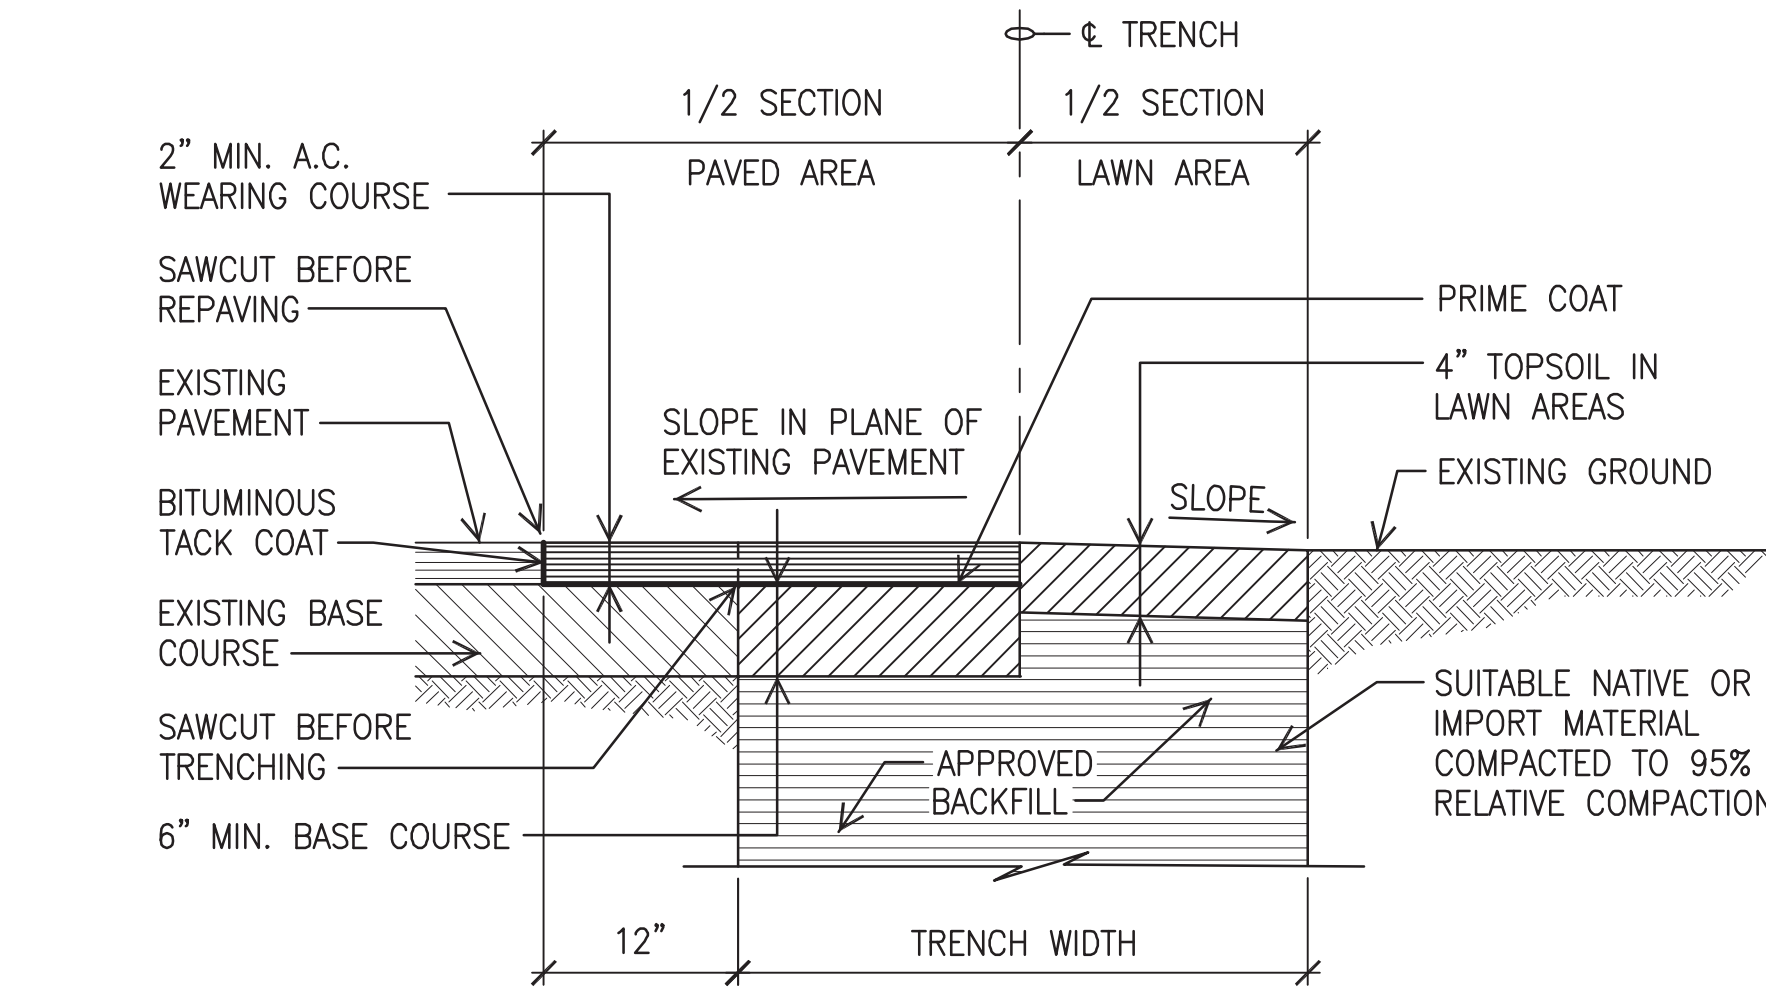


**C** TRENCH RESTORATION DETAIL

E-04 NOT TO SCALE

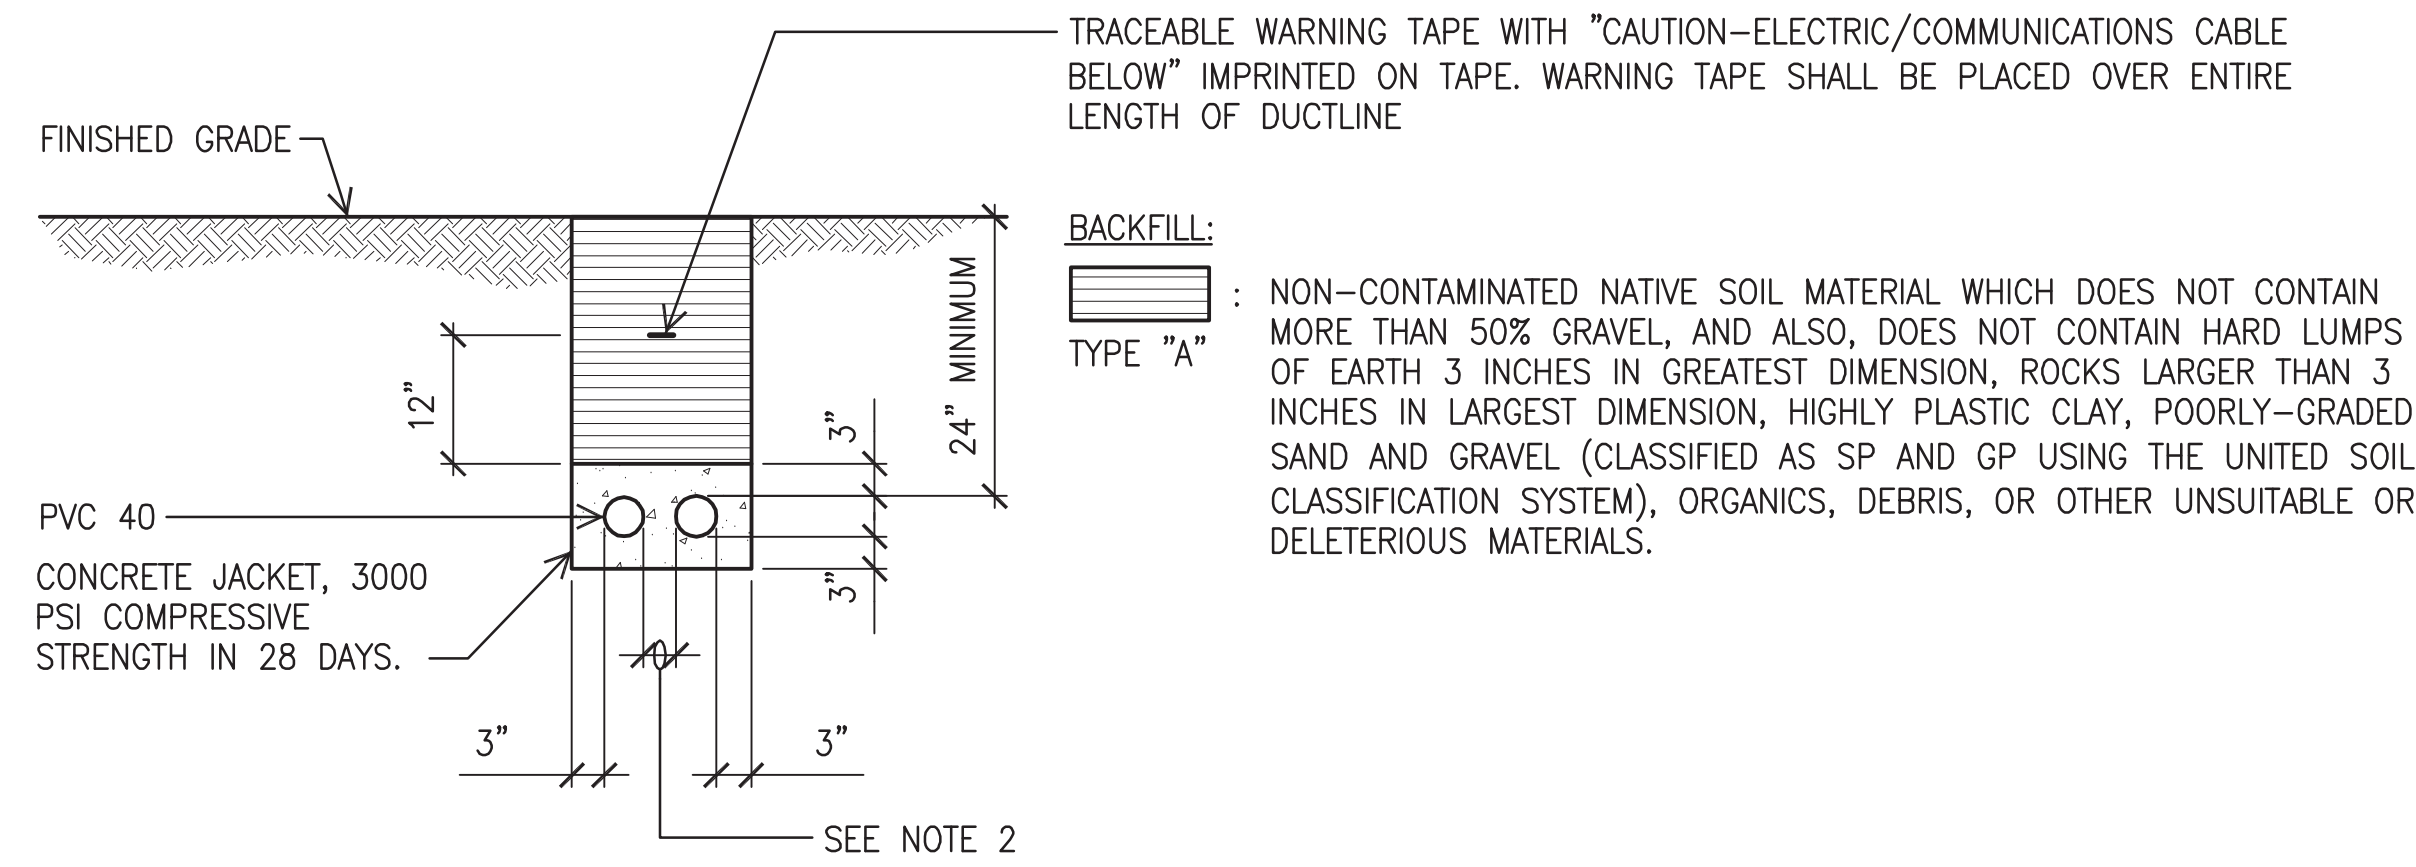


**B** TYPICAL DUCT SECTION (CONCRETE ENCASED)

- E-04 NOT TO SCALE
- NOTES:
- ELECTRICAL AND TELEPHONE DUCTS SIMILAR.
  - PROVIDE 2" SEPARATION BETWEEN DUCTS OF SAME SYSTEM AND 3" BETWEEN DUCTS OF DIFFERENT SYSTEMS.
  - WHERE TRENCH ENCOUNTERS EXISTING CONCRETE OR ASPHALT CONCRETE, SURFACE SHALL BE SAWCUT. BACKFILL, COMPACT AND PATCH SURFACE TO MATCH ADJACENT AREA. SEE TRENCH RESTORATION DETAIL.
  - SEE DUCT SECTION DETAILS FOR CONDUIT ARRANGEMENT.

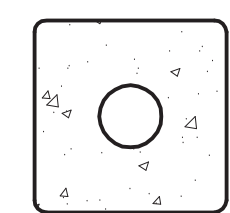

SECTION (A)

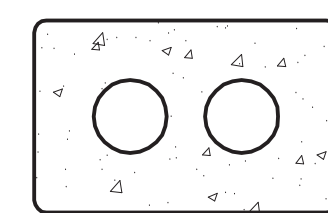

SECTION (B)

**DUCT SECTION DETAILS**

NOT TO SCALE

14002

DATE

APPROVED

SYMBOL

DESCRIPTION

DEPARTMENT OF DEFENSE  
DESIGN AND PROJECT  
MANAGEMENT BRANCH  
HONOLULU, HAWAII

STATE OF HAWAII  
FACILITY MANAGEMENT OFFICE  
HIAENG

HAWAII ARMY NATIONAL GUARD  
PHYSICAL SECURITY AND IMPROVEMENTS  
WAIAWA  
PERIMETER FENCE  
DUCT SECTION DETAILS

SCALE: AS NOTED

STATE JOB NO. CA-1328-D

FEDERAL PROJECT NO. 15140023

SHEET 24 OF 25

E-04




W:\01_PROJECTS\01414002-HIARNG_Phy_Sec_Loc0102_Waiawa\14002-505-0001-0001.dwg, 3/20/15 11:10:40 AM, D:\N_T\14002_505_0001.dwg

D

C

B

A

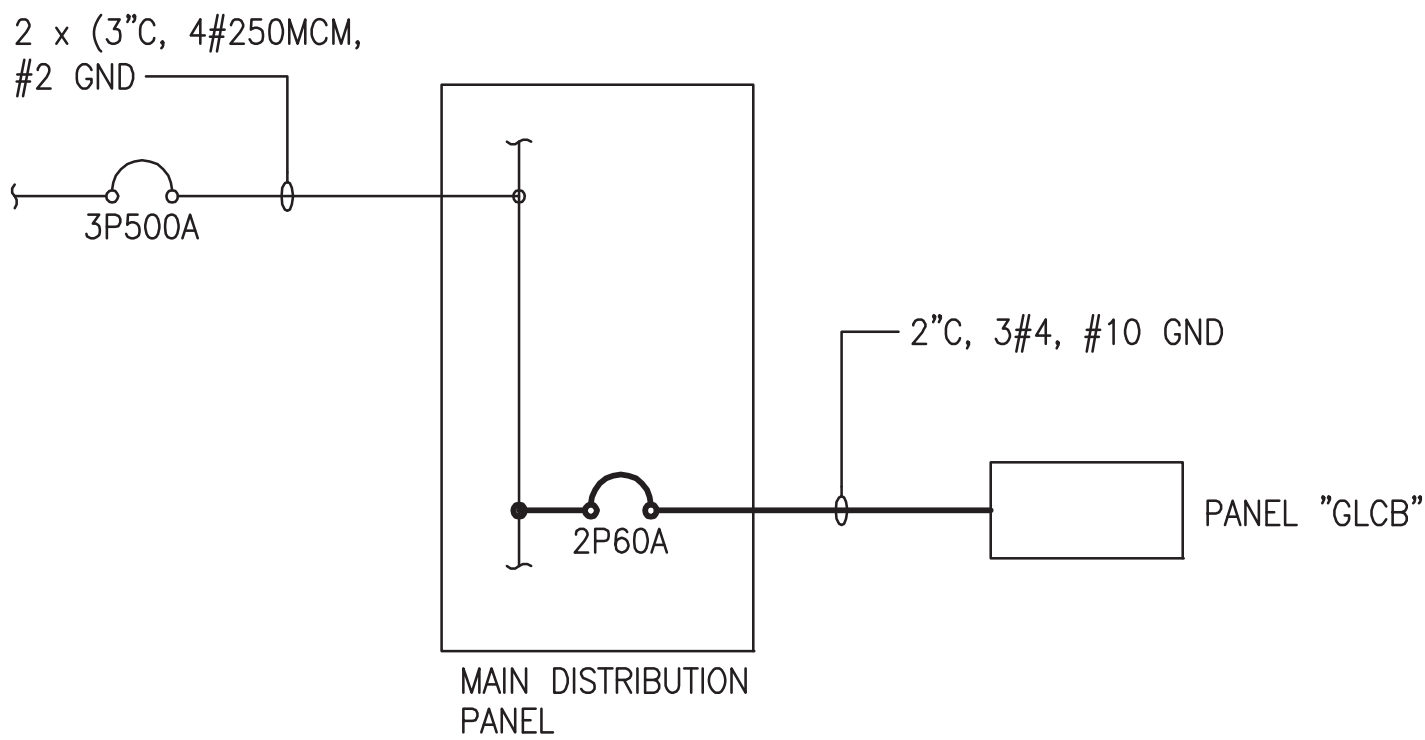


### ONE-LINE DIAGRAM

NO SCALE

#### NOTES:

1. ——— LIGHT LINES DENOTE EXISTING CONDITION  
———— BOLD LINES DENOTE NEW WORK

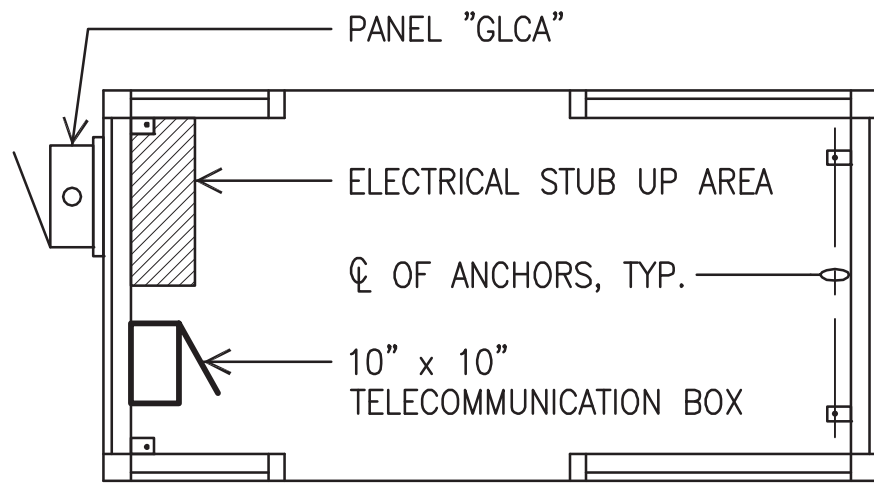

A

E-05

### GUARD SHACK DETAIL

SCALE: 1/2" = 1'-0"

#### NOTES:

1. ——— LIGHT LINES DENOTE EXISTING CONDITION  
———— BOLD LINES DENOTE NEW WORK

#### DISTRIBUTION PANEL

VOLTAGE: 208Y/120V, 3 PH, 4W MAIN BKR: LUGS ONLY  
BUS RATING: 600A TYPE: BOLT-ON  
AIC: 22,000 MOUNT: SURFACE  
ENCLOSURE: NEMA 1 EQUIPMENT GROUND BUS: YES

KVA			DESCRIPTION: L-LIGHTS R-RECEPTACLE, S-SPARE PFB-PROV FOR FUTURE CB	CKT BKR	CKT NO	CKT NO	CKT BKR	DESCRIPTION: L-LIGHTS R-RECEPTACLE, S-SPARE PFB-PROV FOR FUTURE CB	KVA			
A	B	C							A	B	C	
17.0			PANEL C	3P225A	1	2	3P125A	S				
	17.0		PART OF 1	-----	3	4	-----	PART OF 2				
		17.0	PART OF 1	-----	5	6	-----	PART OF 2				
10.0			PANEL E	3P125A	7	8	3P125A	PANEL D	9.0			
	10.0		PART OF 20	-----	9	10	-----	PART OF 8		9.0		
		10.0	PART OF 20	-----	11	12	-----	PART OF 8			9.0	
13.0			PANEL B	3P225A	13	14	2P60A*	GUARD SHACK (NEW)	2.3			
	13.0		PART OF 13	-----	15	16	-----	PART OF 25		2.4		
		13.0	PART OF 13	-----	17	18		PFB				
			PFB		19	20		PFB				
			PFB		21	22		PFB				
			PFB		23	24		PFB				
40.0	40.0	40.0	SUBTOTALS							11.3	11.4	9.0

151.7 TOTAL KVA  
0.8 DEMAND FACTOR  
121.4 DEMAND KVA  
337 DEMAND AMPS 208 volts

NOTES:  
1) * - PROVIDE NEW CIRCUIT BREAKER

#### PANEL "GLC" GE CAT NUMBER TLM1212RCU

VOLTAGE: 208/120V, 1 PH, 3W MAIN BKR: 2P40A  
BUS: COPPER TYPE: PLUG-IN  
BUS RATING: 125A MOUNT: SURFACE  
AIC: 10,000 ENCLOSURE: NEMA 3R EQUIPMENT GROUND BUS: YES  
ISOLATED GROUND BUS: NO  
FEED THRU LUGS: NO  
U.L. LISTED AS SERVICE  
ENTRANCE EQUIPMENT: NO

KVA			DESCRIPTION: L-LIGHTS R-RECEPTACLE, S-SPARE PFB-PROV FOR FUTURE CB	CKT BKR	CKT NO	CKT NO	CKT BKR	DESCRIPTION: L-LIGHTS R-RECEPTACLE, S-SPARE PFB-PROV FOR FUTURE CB	KVA		
A	B								A	B	
1.6			HVAC	1P20A	1	2	1P20A	R-GFCI	0.2		
	1.2		L-GUARD SHACK	1P20A	3	4	1P20A	R-GUARD SHACK		0.2	
			PFB-PROV FOR FUTURE CB		5	6	1P20A	PFB-PROV FOR FUTURE CB			
			PFB-PROV FOR FUTURE CB		7	8	1P20A	PFB-PROV FOR FUTURE CB			
1.6	1.2		SUBTOTALS							0.2	0.2

3.2 TOTAL KVA  
0.8 DEMAND FACTOR  
2.6 DEMAND KVA  
12 DEMAND AMPS 208 volts

NOTES:  
1) * - PROVIDE BREAKER WITH PADLOCKING DEVICE  
2) ** - PROVIDE DEDICATED NEUTRAL  
3) + - PROVIDE ISOLATED GND CONDUCTOR W/BRANCH WIRING  
3) ++ - PROVIDE WITH GFCI TYPE BREAKER

14002



HDR

A/E INFO



MK ENGINEERS, LTD.  
LICENSE EXPIRATION DATE: 4/30/16

SEAL

APPR

DATE

DESCRIPTION

SYM

SUBMITAL PHASE

FINAL

SUBMITAL DATE

03/02/15

DES

PKU

DRW

MKE

CHK

PKU

DEPARTMENT OF DEFENSE

DESIGN AND PROJECT

MANAGEMENT BRANCH

HONOLULU, HAWAII

HAWAII ARMY NATIONAL GUARD

PHYSICAL SECURITY AND IMPROVEMENTS

HIARNG

WAIKAWA

PERIMETER FENCE

ONE-LINE DIAGRAM, PANEL SCHEDULES AND GUARD SHACK DETAIL

SCALE:

AS NOTED

STATE JOB NO.

CA-1328-0

FEDERAL PROJECT NO.

15140023

SHEET

25

OF

25

E-05